


FURNITURE LAYOUT AND EQUIPMENT FLOOR PLAN


SCALE: 1/8" = 1'-0"

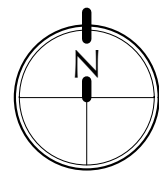

				WATER SERVICE		WASTE SERVICE	GAS	ELECTRICAL SERVICE							REMARKS		
ITEM	QTY	DESCRIPTION	MANUFACTURER AND MODEL	COLD (IN)	COLD (OUT)	HOT	WASTE/ VENT	GAS (IN)	BTUS	VOLTS	PHASE	AMPERAGE	MATTS	HP	TELECOM/ ALARM	TERMINATION	
AA	1	TELLER WINDOW	FEDERAL PROTECTION INC. - 310D														PROVIDED BY OWNER, INSTALLED BY VENDOR
AB	1	TRANSACTION DRAWER	FEDERAL PROTECTION INC. - 400DD							120	1	20				PLUG-IN	PROVIDED BY OWNER, INSTALLED BY VENDOR
AC	2	PNEUMATIC DRIVE-UP TUBE	HAMILTON AIR - HA1000-XLR							120	1	20				HARDWARE	PROVIDED BY OWNER, INSTALLED BY VENDOR
AD	1	CASH VAULT/ NIGHT DROP	FEDERAL PROTECTION INC. - 14-094R							120	1	20			ALARM	HARDWARE	PROVIDED BY OWNER, INSTALLED BY VENDOR
AE	2	SAFETY DEPOSIT	HAMILTON SAFE							115	1	-			ALARM	HARDWARE	PROVIDED BY OWNER, INSTALLED BY VENDOR
AF	5	UNDERCOUNTER TELLER DRAWER	FEDERAL PROTECTION INC. 9-204														PROVIDED BY OWNER, NSTALLED BY VENDOR
AG	1	ATM	FEDERAL PROTECTION INC. NCR SELFSEV 38							110	1				ALARM/ PHONE DATA	HARDWARE	PROVIDED BY OWNER, INSTALLED BY VENDOR, EXISTING
AH	3	LANE SIGN (OPEN/CLOSED)	FEDERAL PROTECTION INC. LG SERIES 82-5							120	1	10				HARDWARE	PROVIDED BY OWNER, INSTALLED BY VENDOR
AI	1	IT RACK WITH EQUIPMENT	TRIPLITE							-	-	-			-	-	PROVIDED BY OWNER, INSTALLED BY CONTRACTOR, EXISTING
AK	1	LANE SIGN (ATM)	FEDERAL PROTECTION INC. LG SERIES 82-5							120	1	10				HARDWARE	PROVIDED BY OWNER, INSTALLED BY VENDOR
AL	1	IT RACK	TRIPLITE							-	-	-	-		-	-	PROVIDED BY OWNER, INSTALLED BY CONTRACTOR, EXISTING
AM	1	REFRIGERATOR														PLUG-IN	PROVIDED BY OWNER, INSTALLED BY CONTRACTOR
AN	1	MICROWAVE														PLUG-IN	PROVIDED BY OWNER, INSTALLED BY CONTRACTOR
AP	1	DISHWASHER														PLUG-IN	PROVIDED BY OWNER, INSTALLED BY CONTRACTOR
AQ	1	AUDIT MACHINE	SHARP AUDIT MACHINE BE-2510L							120	-	-	-		-	PLUG-IN	PROVIDED BY OWNER, EXISTING, INSTALLED BY OWNER
AR	1	MICR	MAVERICK M366 EXCEPTION CHECK ENCODER MICR III							120						PLUG-IN	PROVIDED BY OWNER, EXISTING, INSTALLED BY OWNER
AS	2	BLACK LATERAL FILE	HON														PROVIDED BY OWNER, EXISTING, INSTALLED BY OWNER
AT	1	LASERJET PRINTER	HP LASERJET P2055DN							120	-	-	-		DATA	PLUG-IN	PROVIDED BY OWNER, DESKTOP, EXISTING, INSTALLED BY OWNER
AU	1	CARD/PIN ACTIVATOR, GRAY	DSI #031401							120	-	-	-		DATA	PLUG-IN	PROVIDED BY OWNER, DESKTOP, EXISTING, INSTALLED BY OWNER
AV	6	TELLER COMPUTER	DELL MONITOR, MYSE KEYBOARD AND SLIM TOWER, BASE							120	-	-	-		DATA	PLUG-IN	PROVIDED BY OWNER, DESKTOP, 4 EXISTING, INSTALLED BY OWNER
AW	3	AUDIT MACHINE WITH PAPER	QUICK TELLER							120	-	-	-			PLUG-IN	PROVIDED BY OWNER, DESKTOP, EXISTING, INSTALLED BY OWNER
AX	1	COPIER	CANON HYU14124							120	-	-	-		DATA	PLUG-IN	PROVIDED BY OWNER, EXISTING, INSTALLED BY OWNER
AY	3	RECYCLING/ SHREDDING BINS	N/A; POWDER RIVER SHREDDERS, LLC														PROVIDED BY OWNER, EXISTING, INSTALLED BY OWNER
AZ	1	CHECK SCANNER	CANON IMAGEFORMULA GR-1901							120	-	-	-		DATA	PLUG-IN	PROVIDED BY OWNER, DESKTOP, EXISTING, INSTALLED BY OWNER
BA	1	DOCUMENT SCANNER	FUJITSU FI-7280							120	-	-	-			PLUG-IN	PROVIDED BY OWNER, DESKTOP, EXISTING, INSTALLED BY OWNER
BB	1	CASH ADVANCE MACHINE	VERIFONE VX520												PHONE/ DATA		PROVIDED BY OWNER, DESKTOP, EXISTING, INSTALLED BY OWNER
BC	1	SINGLE CUP COFFEE MAKER	KEURIG K525 WITH STAND, ON 24"X48" TABLE							120	-	-	-			PLUG-IN	PROVIDED BY OWNER, EXISTING, INSTALLED BY OWNER
BD	1	PRINTER/SCANNER	HP DESKJET F340							120	-	-	-		DATA	PLUG-IN	PROVIDED BY OWNER, DESKTOP, EXISTING, INSTALLED BY OWNER
BE	1	PAPER SHREDDER	STAPLES PRO-SERIES							120	-	-	-			PLUG-IN	PROVIDED BY OWNER, EXISTING, INSTALLED BY OWNER
BF	1	COIN SORTER	MACH 6 - #6950/6910							120	-	-	-			PLUG-IN	PROVIDED BY OWNER, EXISTING, INSTALLED BY OWNER
BG	1	CASH/BILL COUNTER	CUMMINS JET COUNT							120	-	-	-			PLUG-IN	PROVIDED BY OWNER, DESKTOP, EXISTING, INSTALLED BY OWNER
BH	1	DE LA RUE CHANGE DRAWER	DE LA RUE, GRAY/BLACK							120	-	-	-			PLUG-IN	PROVIDED BY OWNER, DESKTOP, EXISTING, INSTALLED BY OWNER
BI	1	TAN, DESK MOUNTED COIN EQUIPMENT	BRANDT							120	-	-	-			PLUG-IN	PROVIDED BY OWNER, DESKTOP, EXISTING, INSTALLED BY OWNER
BJ	1	CUSTOM CARD PRINTER, BLACK/GRAY	CUSTOM CARD SYSTEMS							120	-	-	-		DATA	PLUG-IN	PROVIDED BY OWNER, DESKTOP, EXISTING, INSTALLED BY OWNER
BL	1	TAN METAL BOOKSHELF	N/A														PROVIDED BY OWNER, EXISTING, INSTALLED BY OWNER
BM	2	TAN, ADJUSTABLE METAL SHELVLING	N/A														PROVIDED BY OWNER, EXISTING, INSTALLED BY OWNER
BN	1	TAN, 4 TIER FILING CABINET	HON														PROVIDED BY OWNER, EXISTING, INSTALLED BY OWNER
BP	1	ALMOND, 2 TIER WIDE FILING CABINET	N/A														PROVIDED BY OWNER, EXISTING, INSTALLED BY OWNER
BQ	1	ALMOND, 2 TIER FILING CABINET	N/A														PROVIDED BY OWNER, DESKTOP, EXISTING, INSTALLED BY OWNER
BR	5	COMPUTER MONITOR, KEYBOARD AND TOWER	TBD							120	-	-	-		DATA	PLUG-IN	PROVIDED BY OWNER, DESKTOP, 4 EXISTING, INSTALLED BY OWNER
BS	2	FLAT SCREEN TV AND BRACKET	TBD							120	-	-	-		DATA	PLUG-IN	PROVIDED BY OWNER, INSTALLED BY CONTRACTOR
BT	1	CONFERENCE EQUIPMENT	TBD							120	-	-	-		DATA	PLUG-IN	PROVIDED BY OWNER, INSTALLED BY OWNER
BU	2	LATERAL FILE CABINET	FIRE KING														PROVIDED BY OWNER, EXISTING, INSTALLED BY OWNER
BV	1	LASERJET PRINTER	HP LASERJET 4300 DTN							120	-	-	-		DATA	PLUG-IN	PROVIDED BY OWNER, EXISTING, INSTALLED BY OWNER



PLATTE VALLEY BANK
5271 EAST 2ND STREET
CASPER, WY 82609

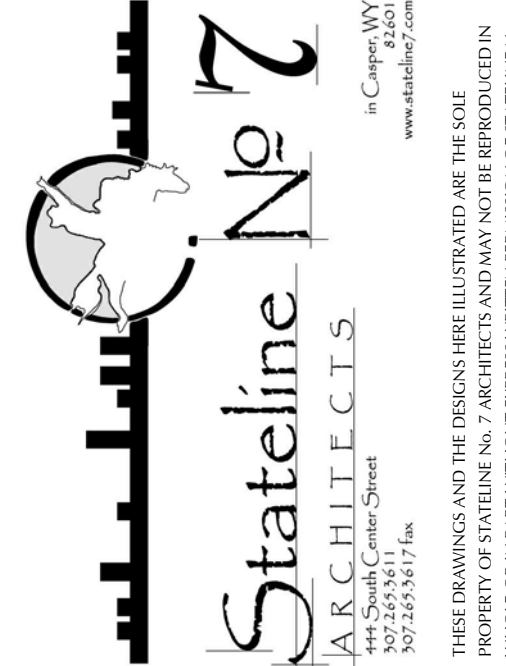

PROJECT NUMBER
15-005

DATE
JANUARY 27, 2017

DRAWN BY
A. WILLIAMSON
D. LITTLE

DISK ID.
15-015 PLATTE VALLEY BANK_CENTRAL.RVT
SHEET TITLE
EQUIPMENT PLAN

SHEET NUMBER
3.25