


**FIRST FLOOR REFLECTED CEILING PLAN**

SCALE: 1/4" = 1'-0"

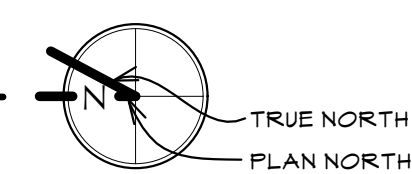


**GENERAL NOTES**


1. GENERAL NOTES, KEYNOTES, AND LEGEND ON THIS SHEET REFER TO THIS SHEET ONLY.
2. SEE CIVIL, STRUCTURAL, MECHANICAL, AND ELECTRICAL PLANS FOR ADDITIONAL INFORMATION.
3. ALL DIMENSIONS ARE TO THE FACE OF FOUNDATION, MASONRY, OR STUDS UNLESS NOTED OTHERWISE.
4. PROVIDE FLUSH METAL (FIRE RATED WHERE REQUIRED) CEILING AND HALL ACCESS DOORS OF SIZE NECESSARY TO ACCESS MECHANICAL AND ELECTRICAL ITEMS REQUIRING ACCESS - SEE THE SPECIFICATIONS, COORDINATE WITH THE MECHANICAL AND ELECTRICAL REQUIREMENTS AND VERIFY QUANTITIES, SIZE AND LOCATIONS (ACCESS DOORS ARE NOT SHOWN ON THIS SHEET).

**LEGEND**

- 5/8" GYPSUM BOARD CEILING
- EXISTING ITEMS - TO REMAIN UNLESS NOTED OTHERWISE
- LIGHT FIXTURES, SEE ELECTRICAL SHEETS
- SUPPLY GRILLE, SEE MECHANICAL DRAWINGS
- EXHAUST GRILLE, SEE MECHANICAL DRAWINGS
- RETURN GRILLE, SEE MECHANICAL DRAWINGS
- STRUCT. OPEN TO STRUCTURE ABOVE
- CEILING TO BE INSTALLED AT HEIGHT INDICATED ABOVE THE FINISH FLOOR SURFACE IMMEDIATELY BELOW
- CEILING TO BE INSTALLED DIRECTLY TO BOTTOM OF STRUCTURE ABOVE
- UNIT HEATER, SEE MECHANICAL DRAWINGS
- INDICATES LINE OF FIRE RATING, SEE THE FLOOR PLAN

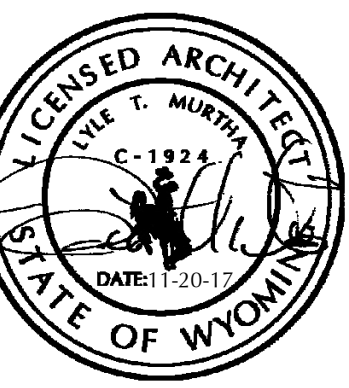

OLD STONEY REMODEL  
 PHASE ONE  
 108 NORTH 4TH STREET  
 SUNDANCE, WYOMING 82729

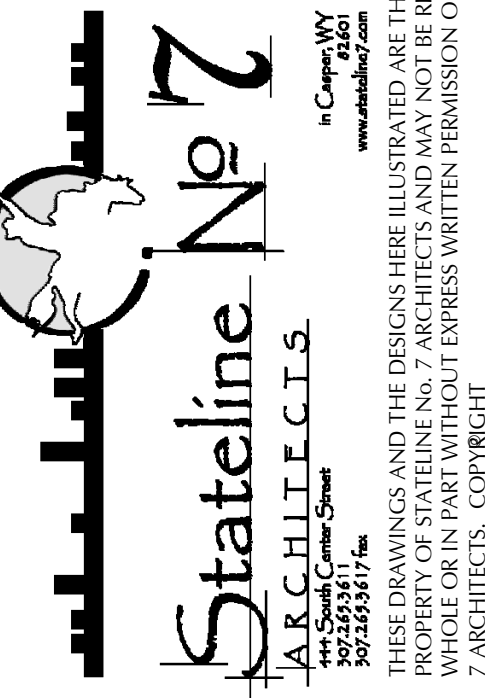

PROJECT NUMBER  
 16-022

DATE  
 11-20-2017


DRAWN BY  
 KFOX  
 A WILLIAMSON

DISK ID.  
 16-022 Old  
 Stoney/16-022\_Old  
 Stoney.rvt


SHEET TITLE  
 FIRST FLOOR  
 REFLECTED  
 CEILING PLAN

SHEET NUMBER

3.70

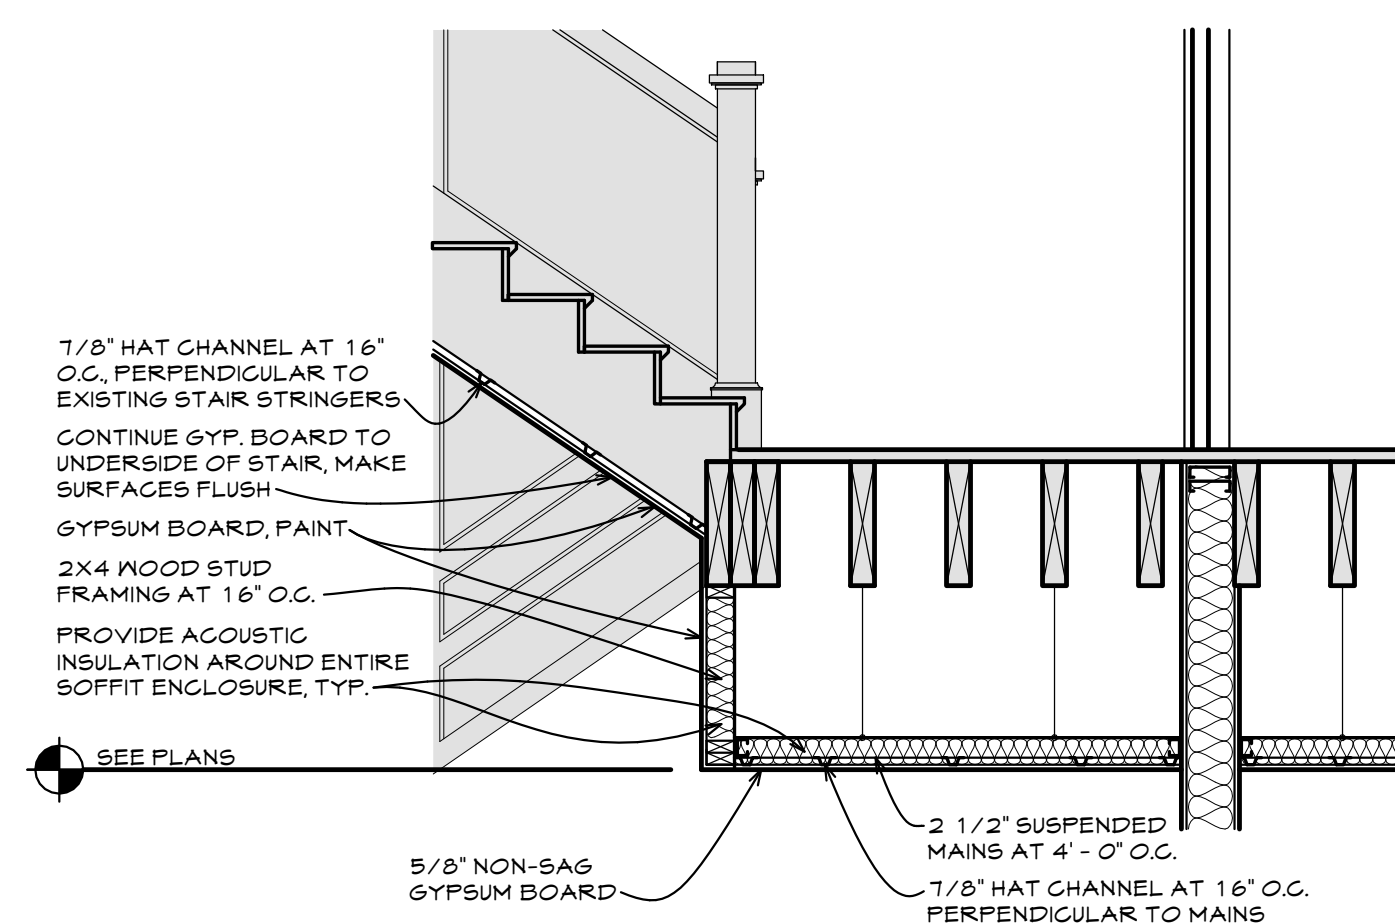

1 SOFFIT DETAIL  
 SCALE: 1/2" = 1'-0"

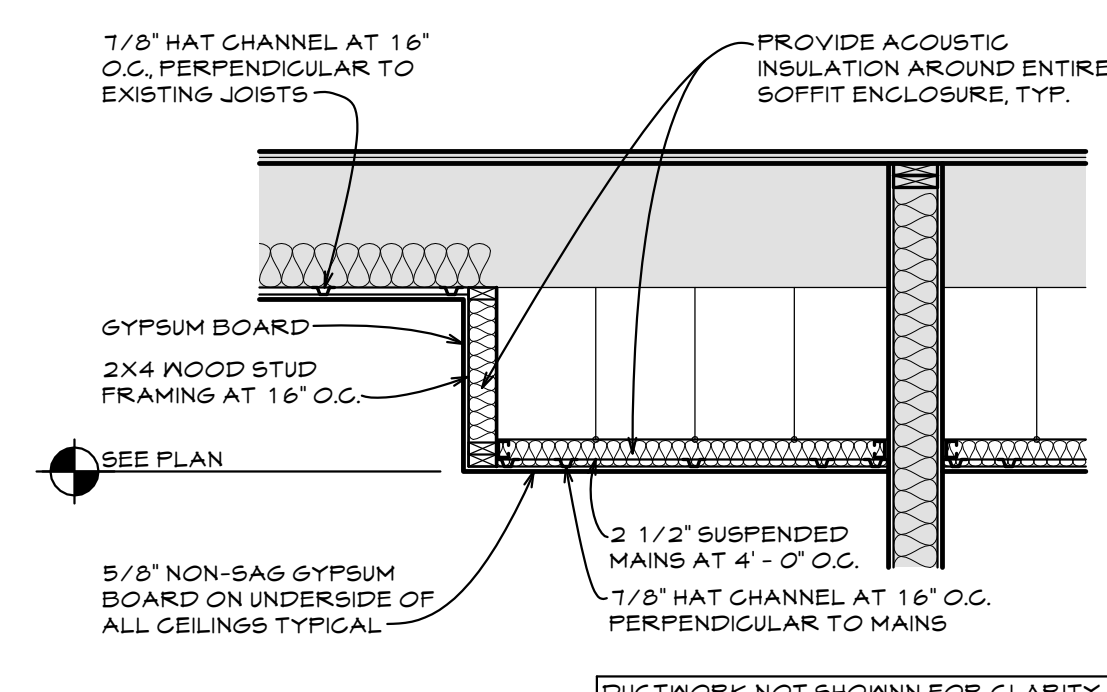

2 SOFFIT DETAIL  
 SCALE: 1/2" = 1'-0"

DUCTWORK NOT SHOWN FOR CLARITY. SEE THE MECHANICAL DRAWINGS