


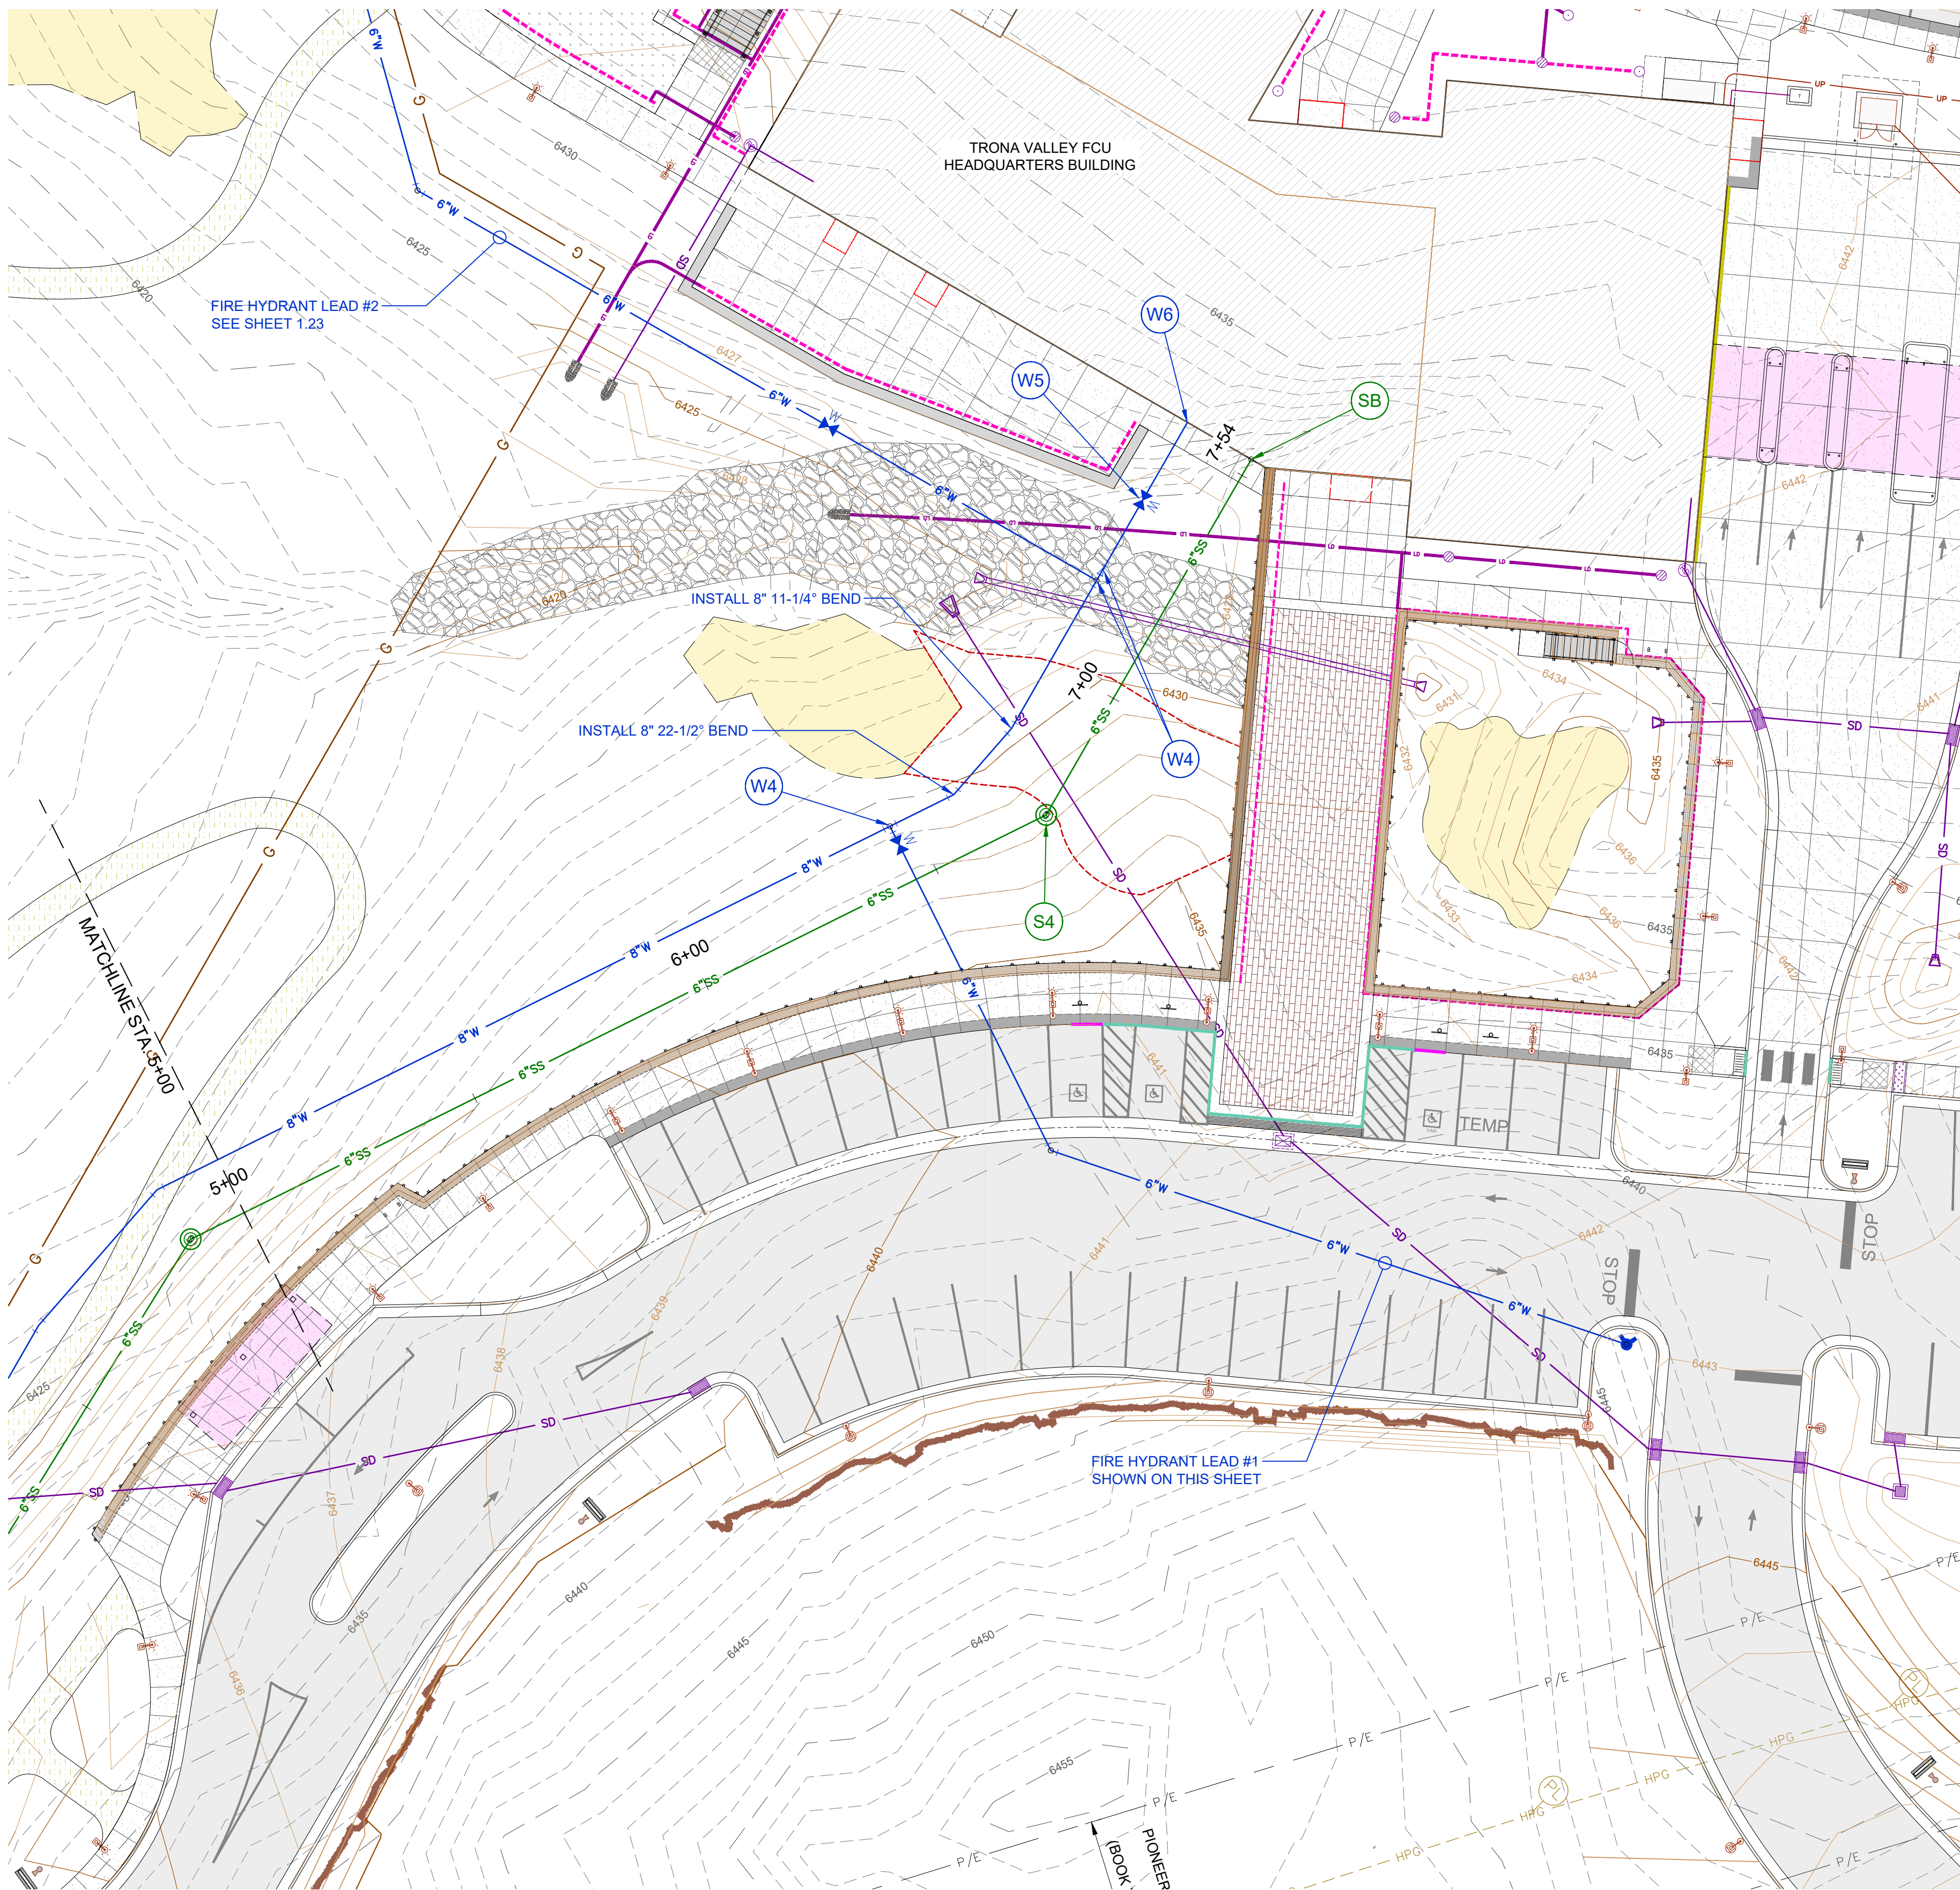

(W4) INSTALL 8"x8"x6" TEE
INSTALL 8"x6" REDUCER @ TEE (HYD LEAD #2)

(W5) INSTALL 6" GATE VALVE

(W6) END 6" WATER MAIN AT BUILDING
SEE MECHANICAL PLANS FOR
CONTINUATION

WATER LINE GENERAL NOTES:

1. ALL WATER VALVE BOXES SHALL BE SURROUNDED BY A CONCRETE COLLAR, SEE DETAIL ON SHEET 1.40
2. SEE UTILITY TRENCH DETAIL ON SHEET 1.40 FOR PIPE INSTALLATION
3. SEE DETAILS ON SHEET C1.40 FOR WATER LINE INSTALLATION DETAILS

(S4) STA 6+73.87 - 48" Ø MANHOLE #4
RIM ELEV = 6432.00
I.E. IN (N) 6" PVC = 6421.40
I.E. OUT (SW) 6" PVC = 6421.30

(SB) STA 7+53.60 - AT BUILDING
I.E. OUT (S) 6" PVC = 6423.00
SEE MECHANICAL PLANS FOR
CONTINUATION



SANITARY SEWER LINE GENERAL NOTES:

1. ALL MANHOLES SHALL BE SURROUNDED BY A CONCRETE COLLAR, SEE DETAIL ON SHEET 1.40
2. SEE UTILITY TRENCH DETAIL ON SHEET 1.40 FOR PIPE INSTALLATION
3. SEE DETAILS ON SHEET C1.40 FOR SANITARY SEWER INSTALLATION DETAILS


(W5) INSTALL 6" GATE VALVE

(W7) CONNECT TO 8"x8"x6" TEE

(W8) INSTALL FIRE HYDRANT ASSEMBLY
SEE DETAIL ON SHEET 1.40

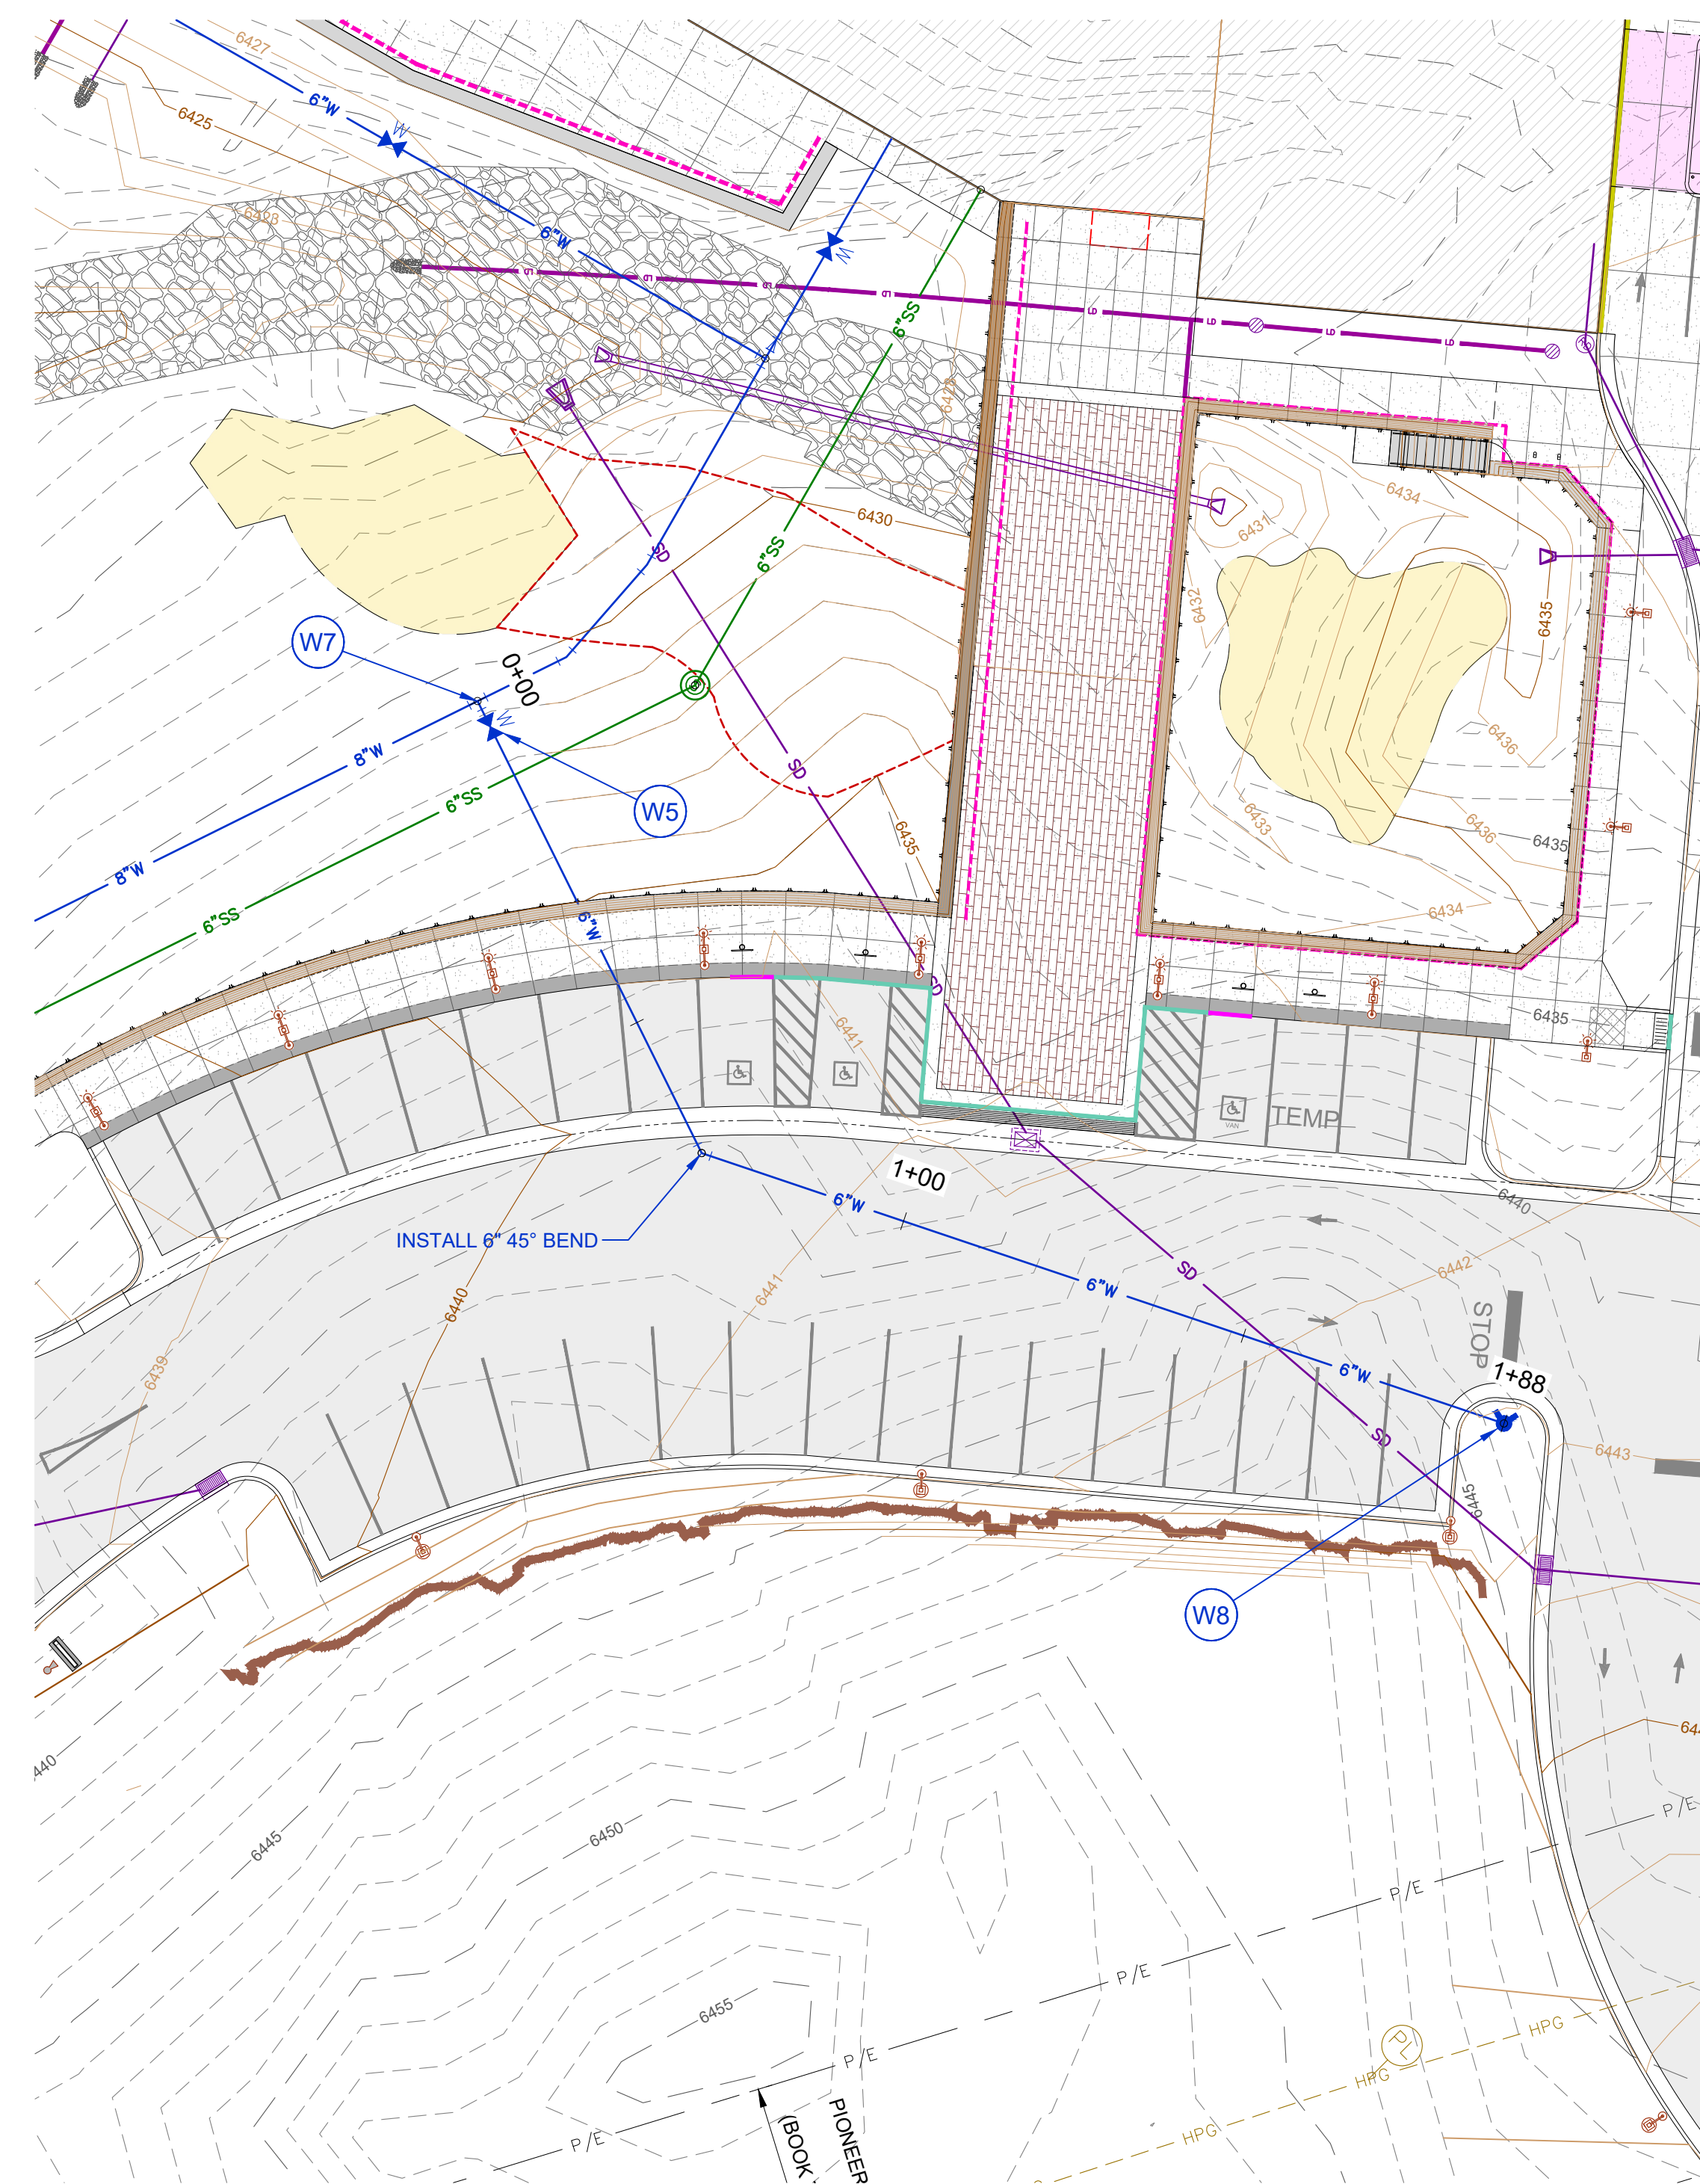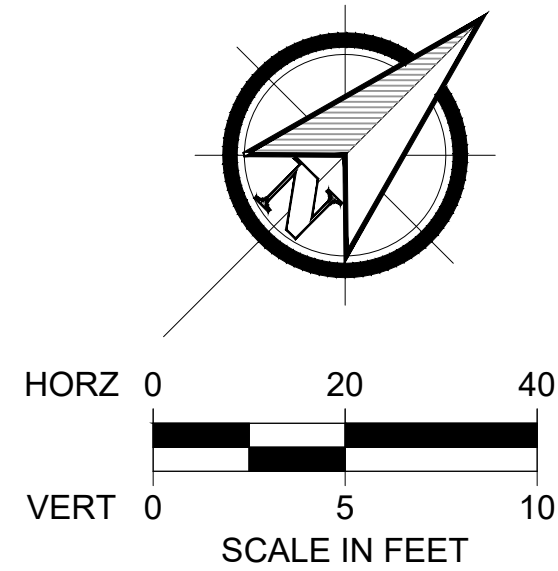


UTILITIES PROFILE
5+00 TO 8+00

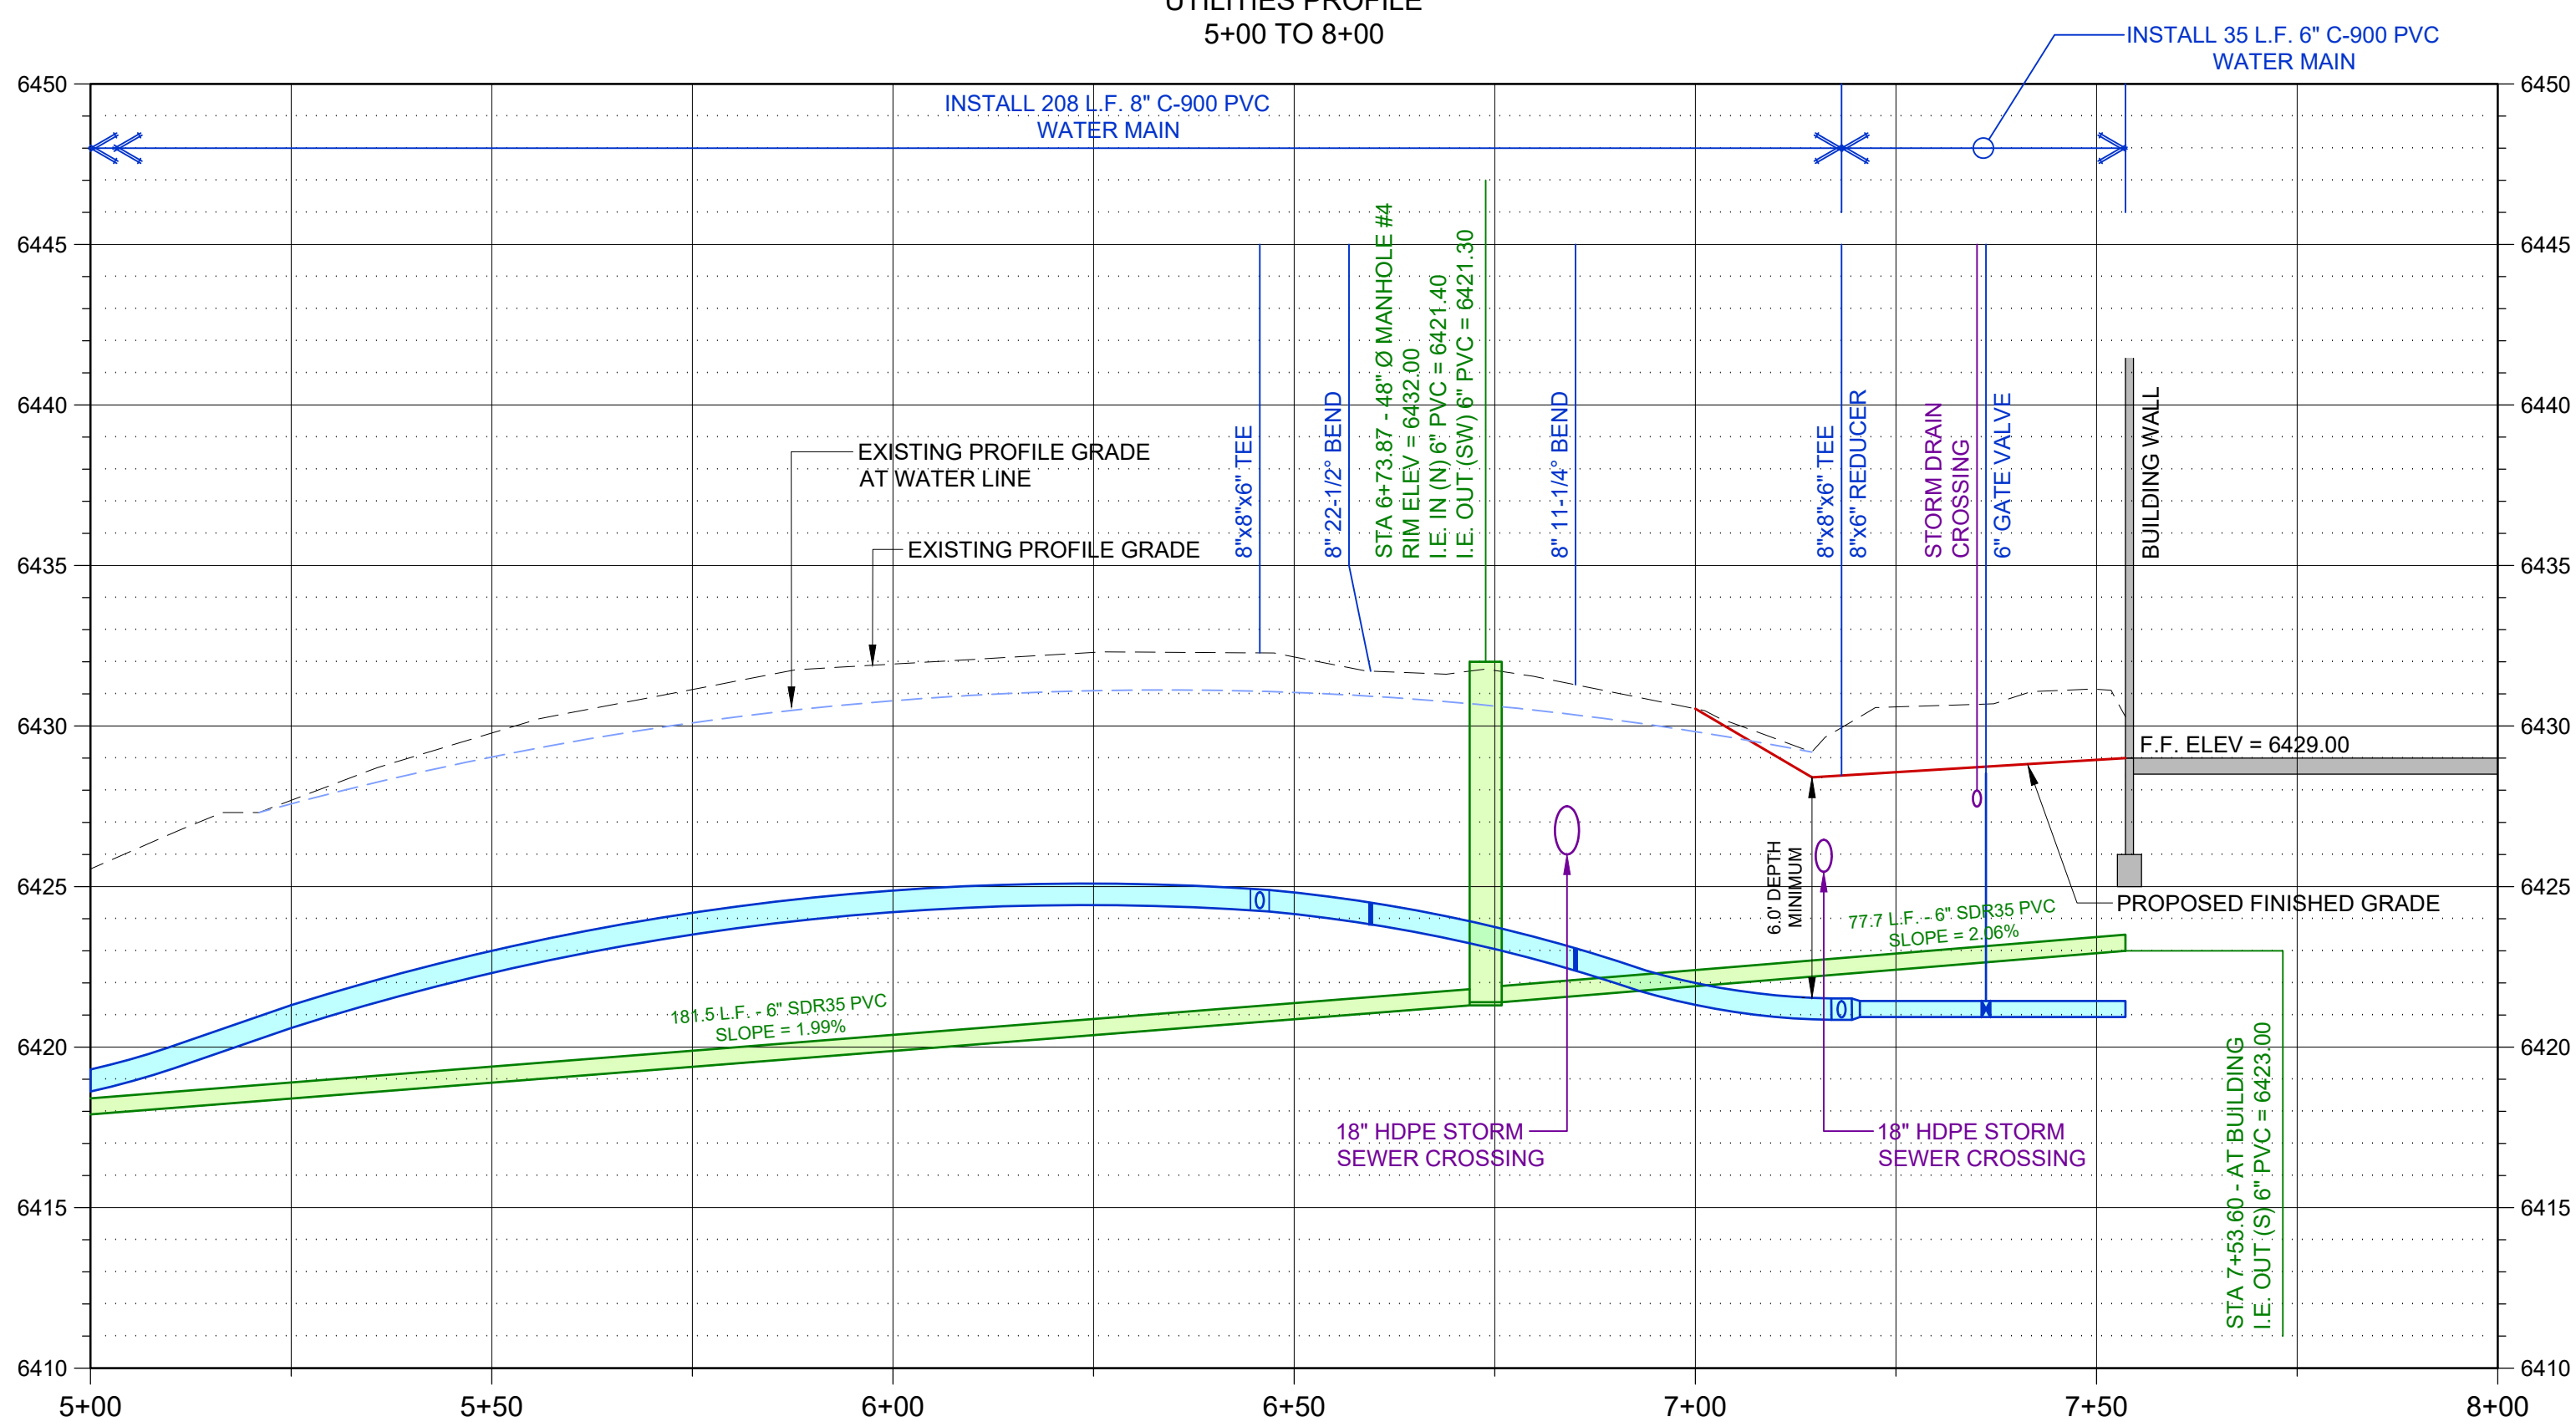

WATER AND SANITARY SEWER SERVICES


UTILITIES PROFILE
0+00 TO 2+00

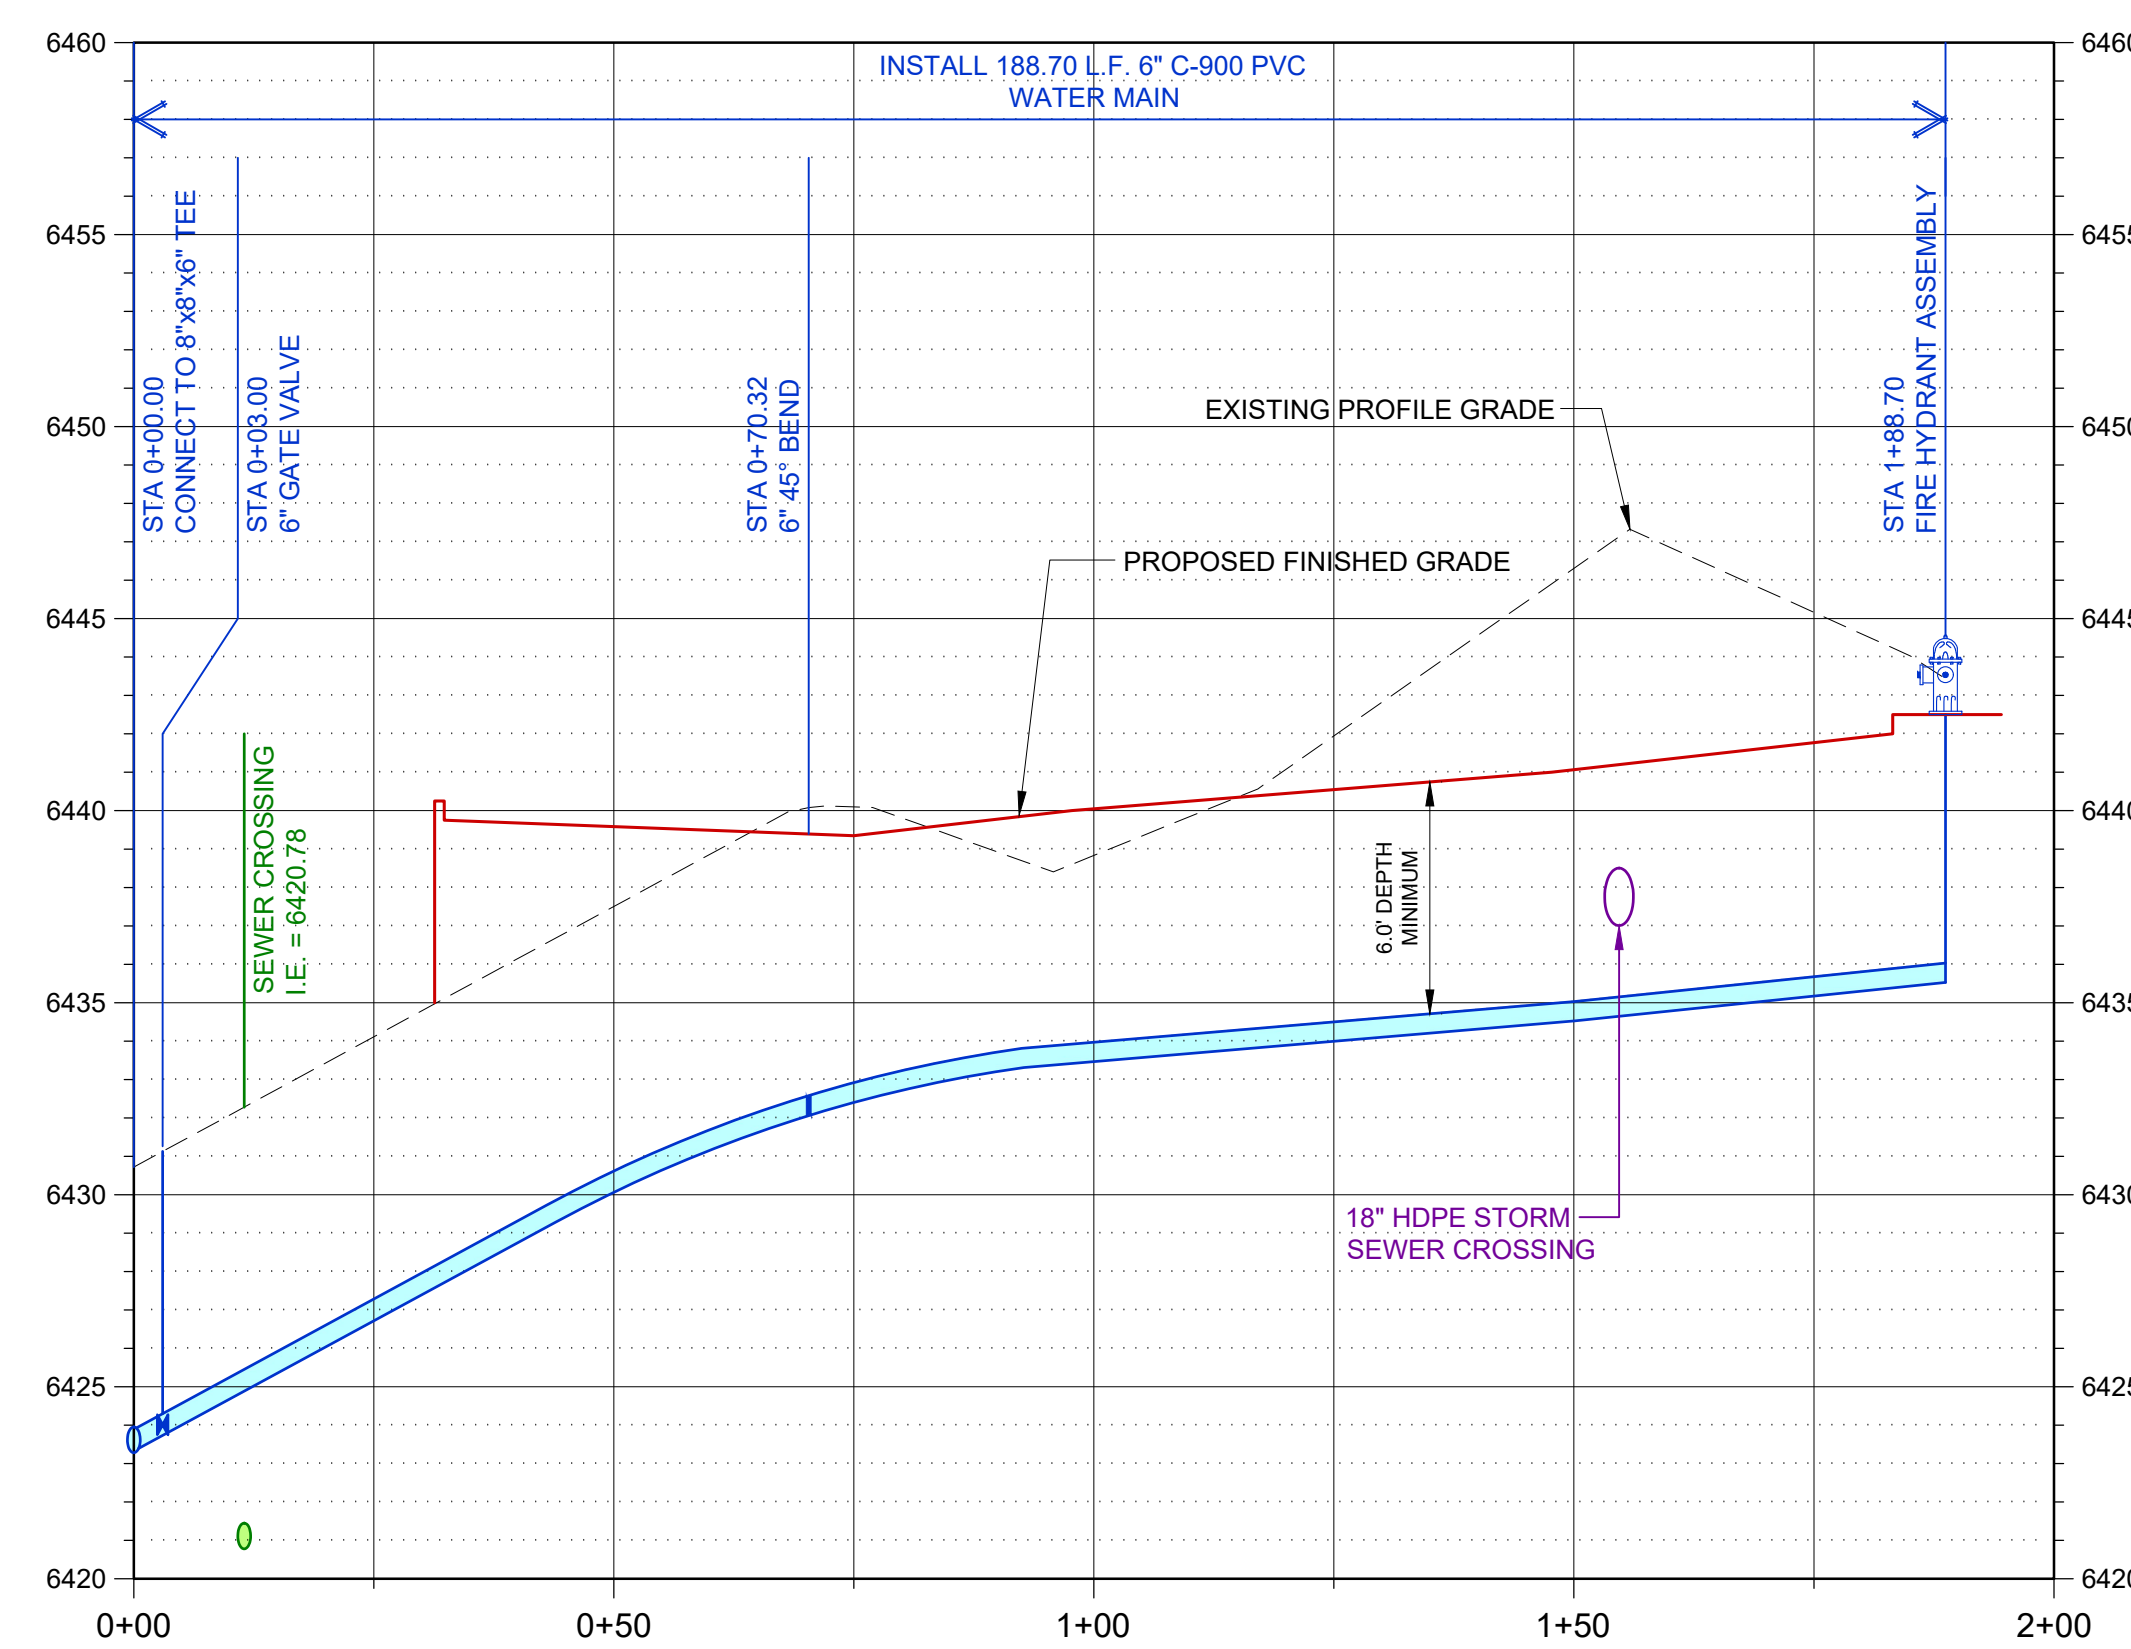

FIRE HYDRANT LEAD #1



TRONA VALLEY FEDERAL CREDIT UNION
1700 GATEWAY BLVD
ROCK SPRINGS, WYOMING 82901

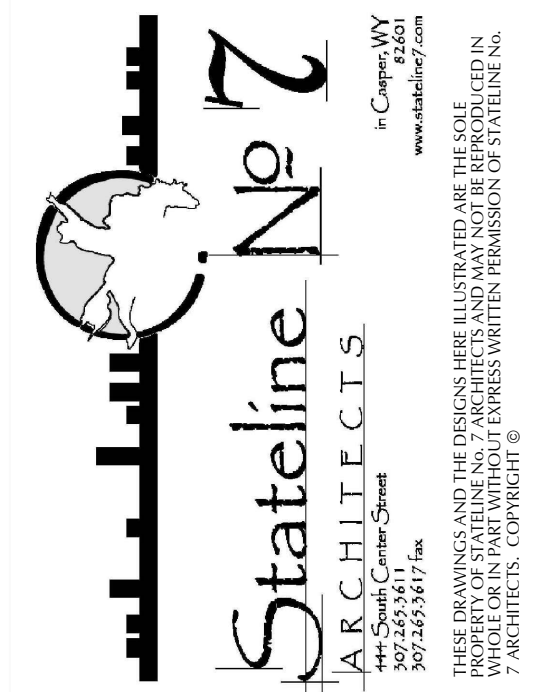

PROJECT NUMBER
WHS - 24001

DATE
9-27-2025

DRAWN BY
WHS - KBK

DISK ID.

SHEET TITLE
NAME
WATER
AND
SANITARY SEWER
PLAN & PROFILES

SHEET NUMBER

1.22