


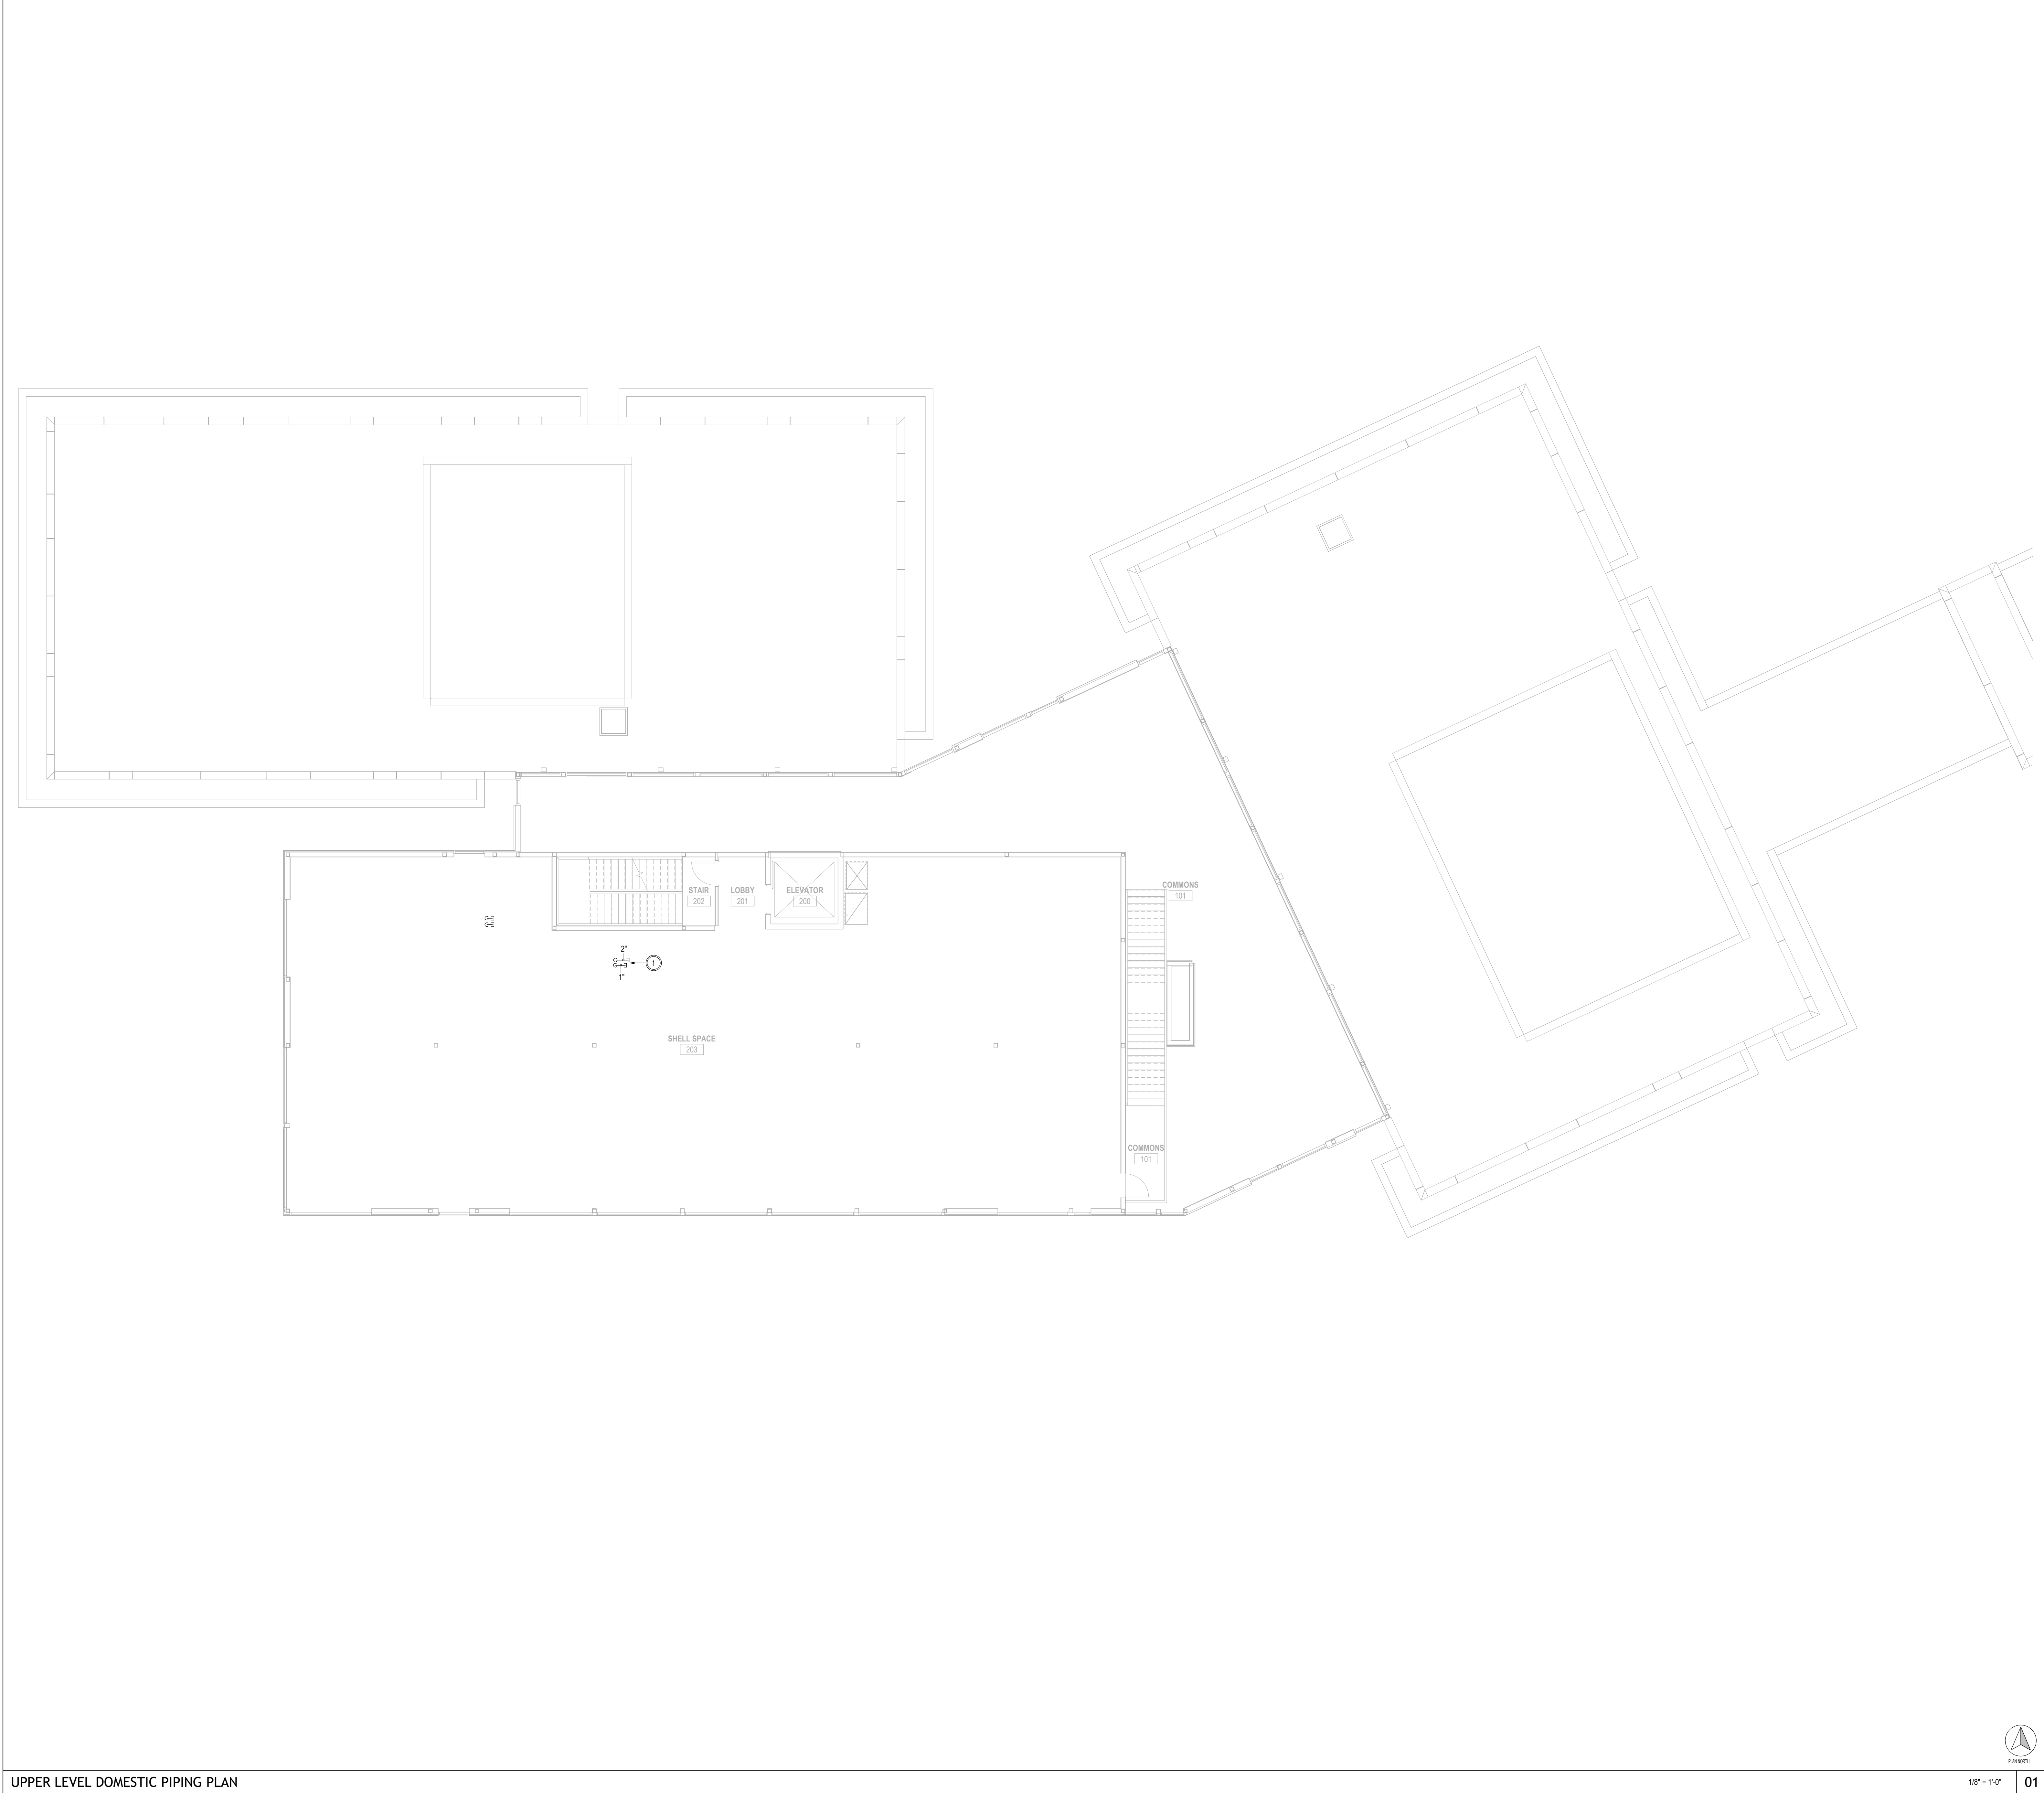

UPPER LEVEL DOMESTIC PIPING PLAN



GENERAL NOTES

A. INSTALL ALL PLUMBING PIPING WITHIN FRAMED WALLS OR ABOVE CEILINGS TIGHT TO OR WITHIN STRUCTURE UNLESS NOTED OTHERWISE. COORDINATE LOCATIONS WITH OTHER TRADES PRIOR TO INSTALLATION. PLAN OFFSETS AS REQ'D TO AVOID CONFLICTS WITH DUCTWORK AND/ OR STRUCTURE.


B. SLEEVE ALL WALL PENETRATIONS ALLOWING FOR FREE MOVEMENT DUE TO PIPE EXPANSION. SEAL PENETRATIONS THRU RATED CONSTRUCTION WITH A FIRE SAFE MATERIAL AND ALL OTHERS WITH AN ACOUSTIC CAULK.

KEY NOTES

1. ROUGH-IN FOR FUTURE RESTROOMS SAME AS BELOW. CAP WATER LINES JUST ABOVE THE FLOOR LEVEL.

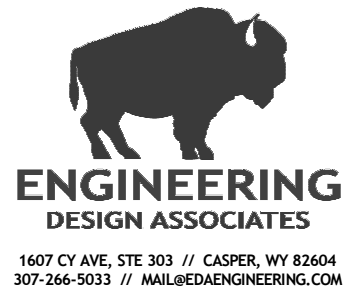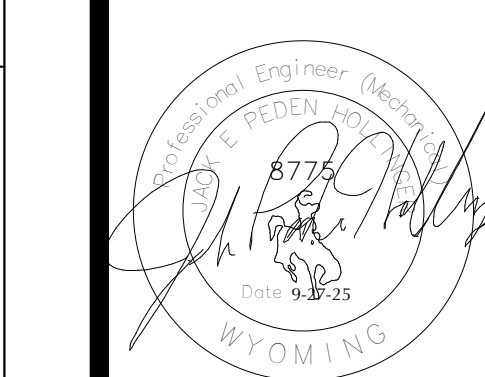

TRONA VALLEY FEDERAL CREDIT UNION
1700 GATEWAY BLVD
ROCK SPRING, WY 82901

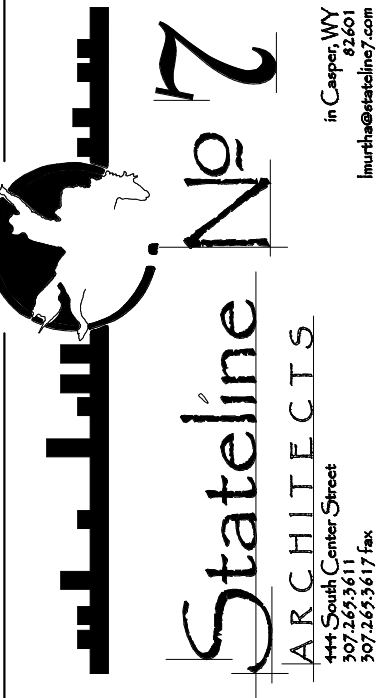

PROJECT
24112

DATE
09-27-2025

DRAWN BY
GMH

DISK ID.

SHEET
UPPER LEVEL
DOMESTIC PIPING

SHEET

15.32