



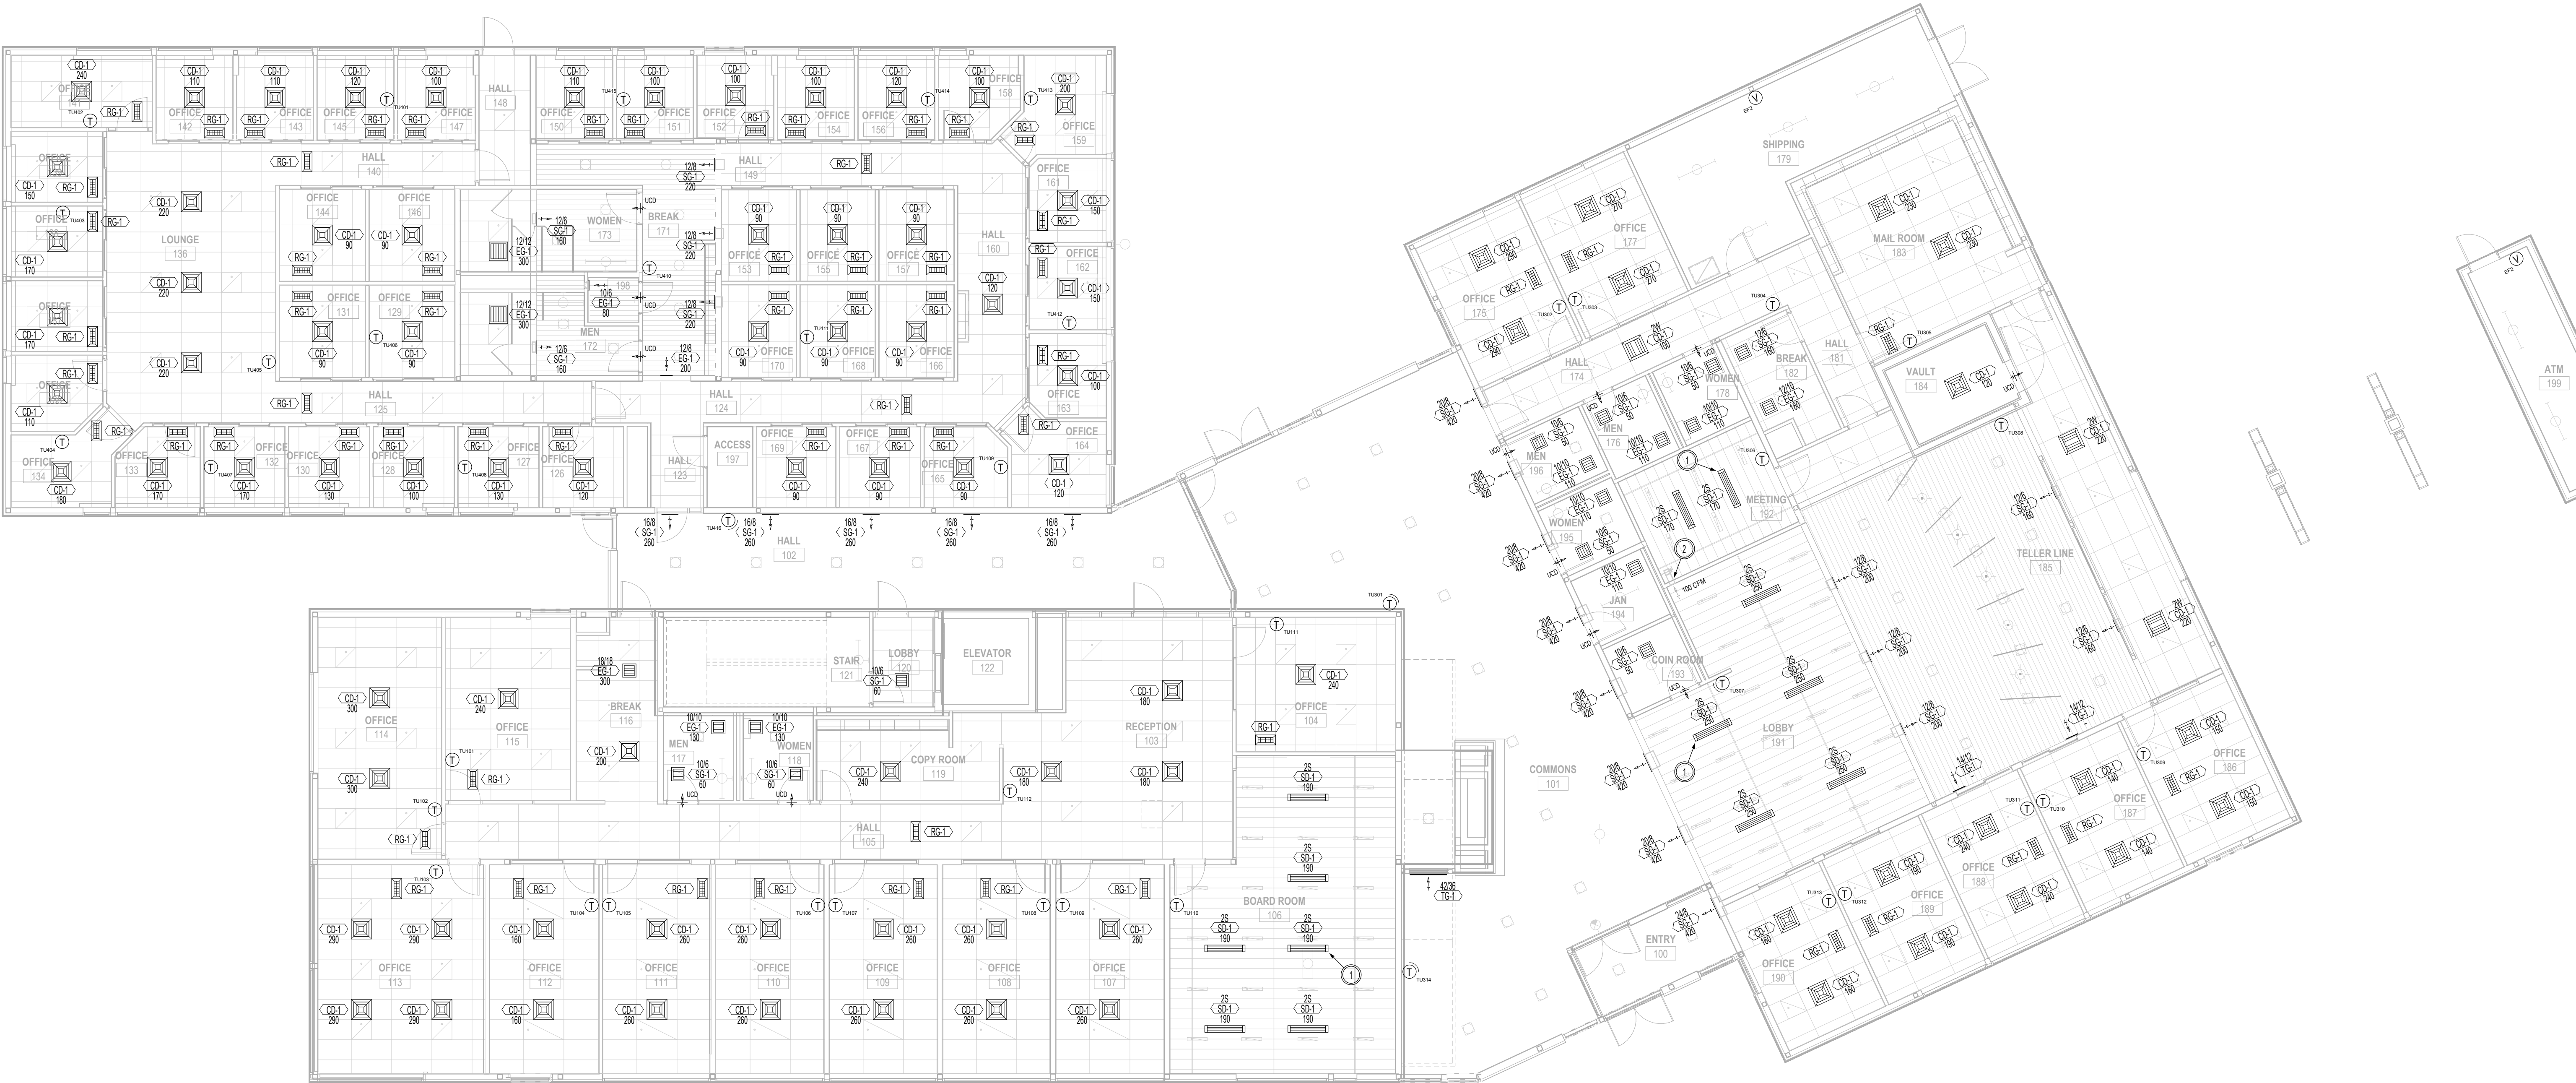


GENERAL NOTES


- A. AIR DEVICE LOCATIONS ARE SHOWN APPROXIMATE. CONFIRM ALL LOCATIONS WITH THE ARCHITECT AND COORDINATE WITH ACTUAL CONDITIONS.
- B. ZONE SENSORS INDICATED WITH A "T" INCLUDE DISPLAY, ADJUSTMENT, AND OVERRIDE. SENSORS INDICATED WITH AN "S" ARE WITHOUT DISPLAY OR ADJUSTMENT. LINE OR LOW VOLTAGE STATUS ARE INDICATED "Y".
- C. INSTALL CONTROL WIRING WITHIN EMT IN EXPOSED LOCATIONS. PLENUM RATED CABLE IS ACCEPTABLE WITHIN CONCEALED ACCESSIBLE LOCATIONS ONLY.
- D. BAS FLOOR PLAN GRAPHIC PAGES SHALL INCLUDE NAVIGATION LINKS AND ALARM STATUS DISPLAY FOR EACH PLANT AND THE AIR HANDLER.

KEY NOTES

1. LOCATE SLOT DIFFUSER EVENLY SPACED IN WOOD PLANK CEILINGS AS SHOWN. COORDINATE LOCATIONS WITH THE GC. TYPICAL.
2. BALANCE OPEN ENDED EXHAUST ABOVE THE CEILING AS INDICATED.

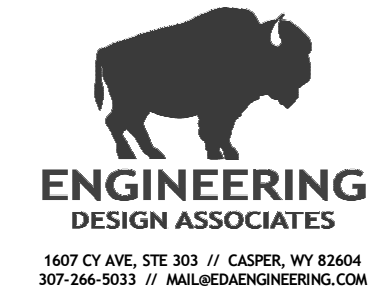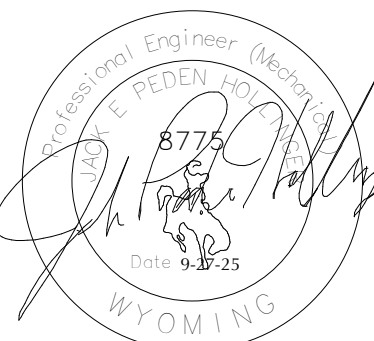

TRONA VALLEY FEDERAL CREDIT UNION
1700 GATEWAY BLVD
ROCK SPRING, WY 82901

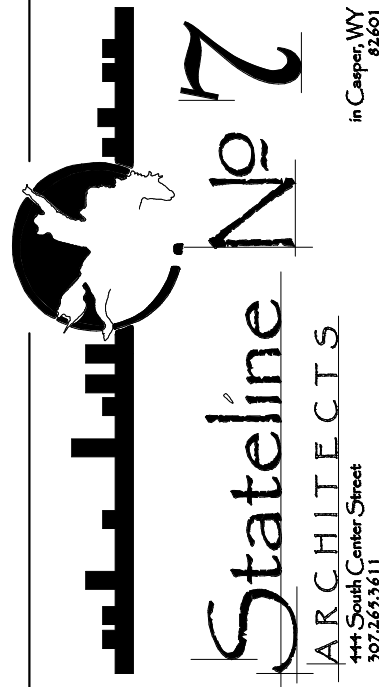

PROJECT
24112

DATE
09-27-2025

DRAWN BY
GMH

DISK ID.

SHEET
MAIN LEVEL
TAB & BAS

SHEET

15.61