




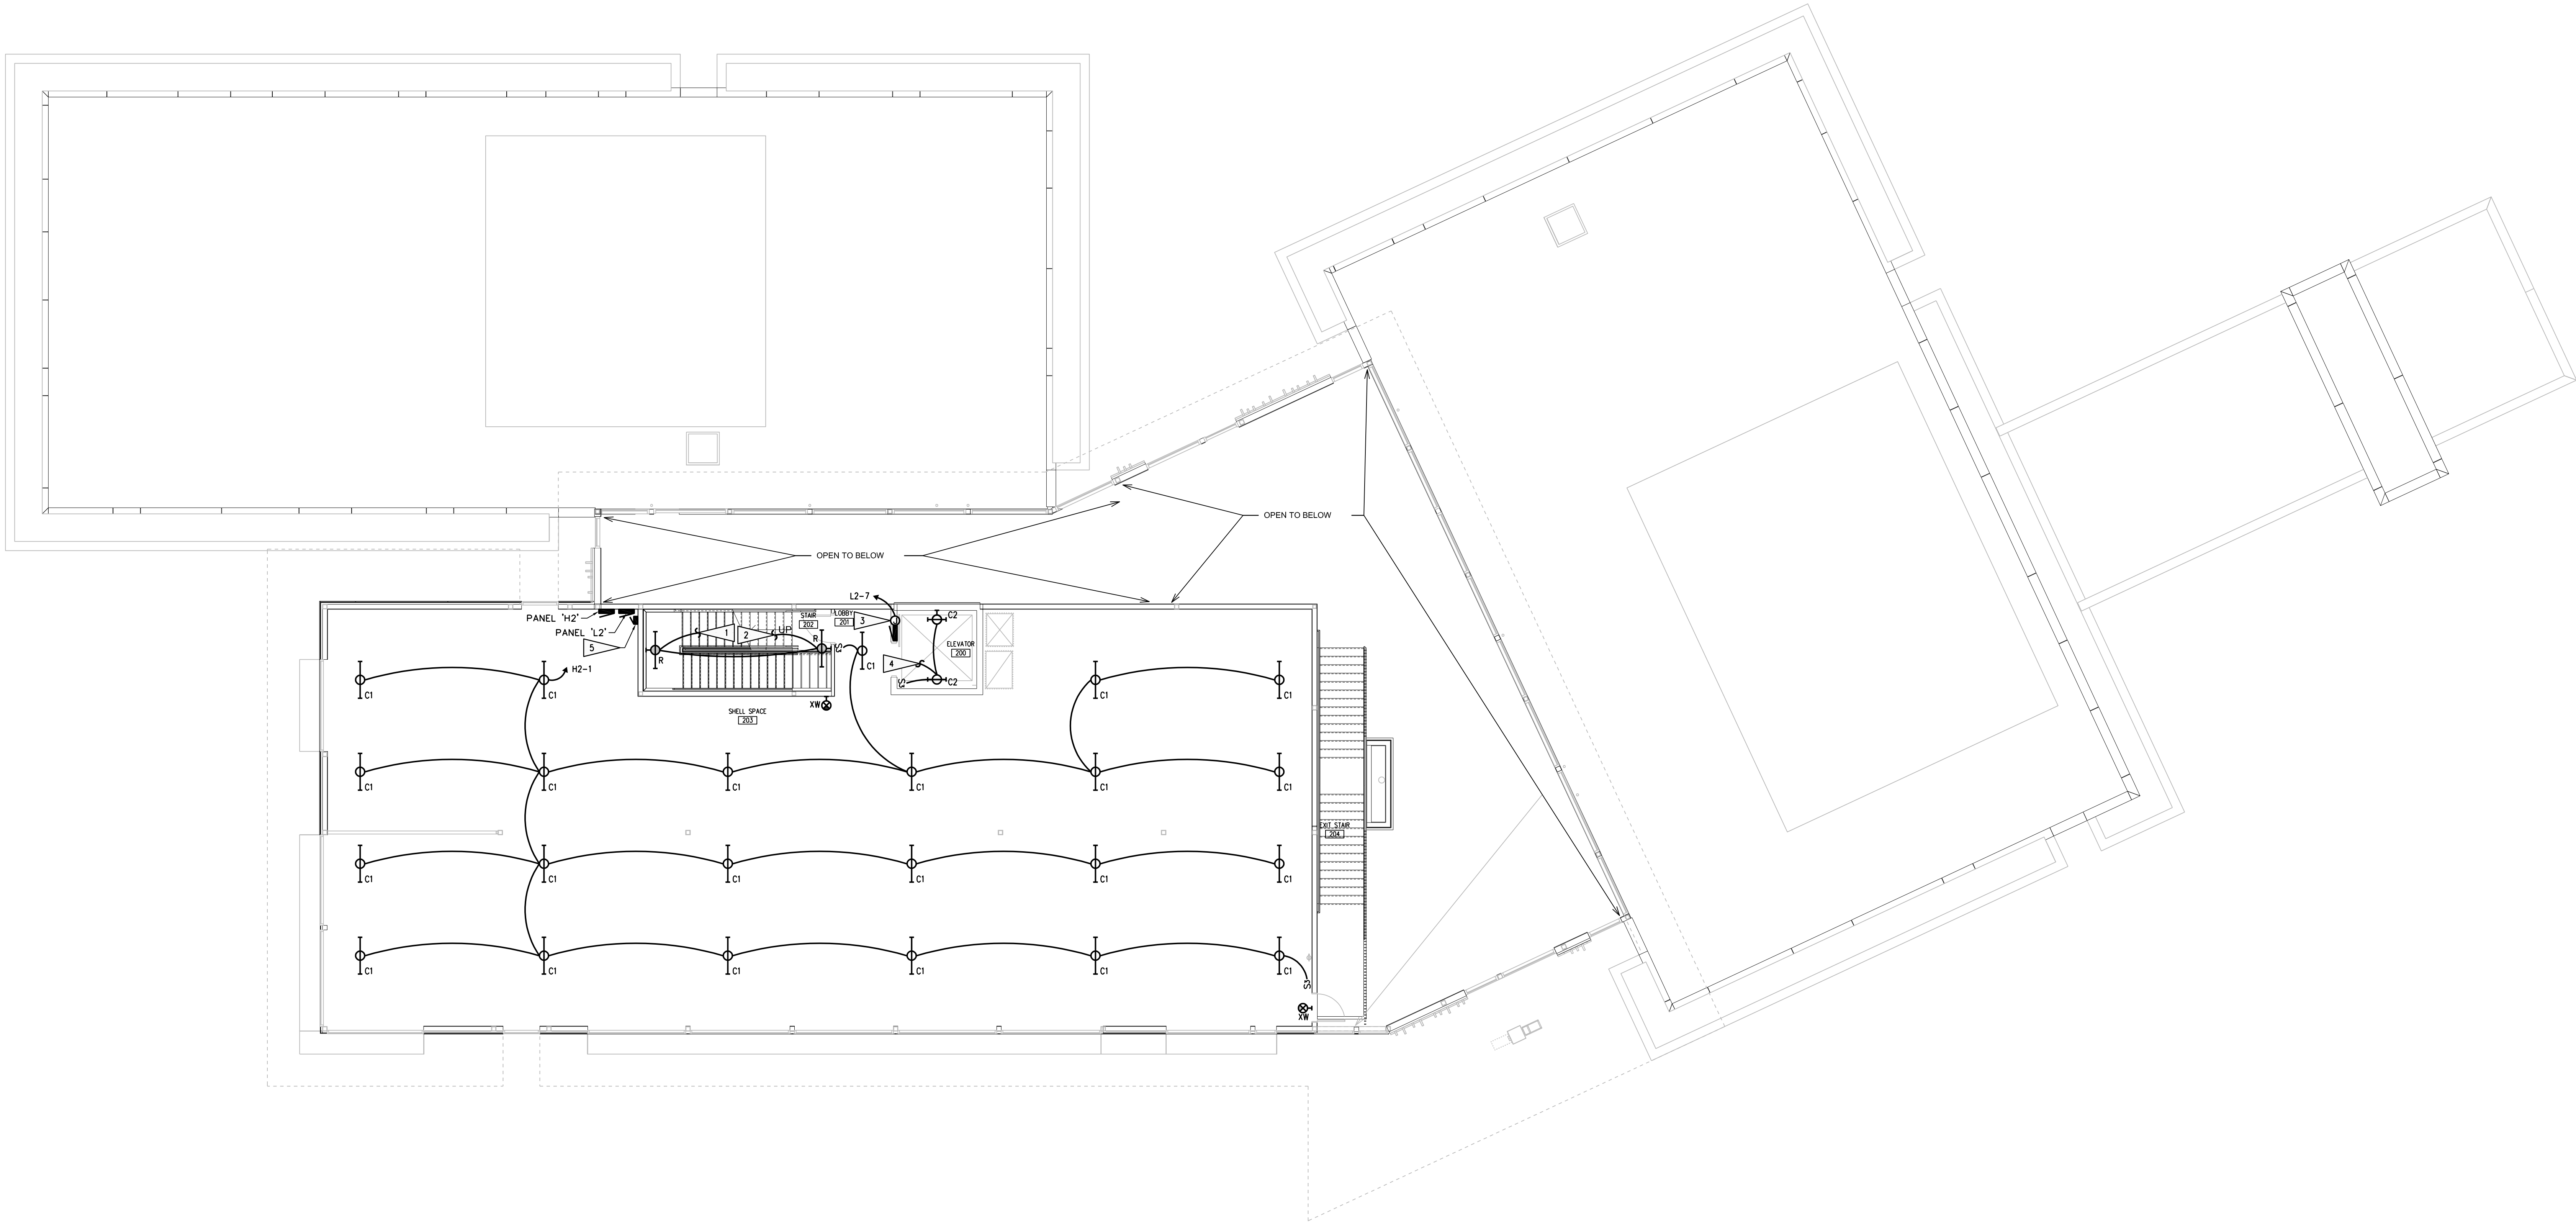

FLAG NOTES	GENERAL NOTES
1 CONNECT TO STAIR LIGHTING ON FLOOR BELOW.	1. SEE SPECIFICATIONS FOR MATERIALS AND METHODS.
2 CONNECT TO STAIR LIGHTING ON FLOOR ABOVE.	2. ELECTRICAL INSTALLATIONS SHALL COMPLY WITH CURRENT ADOPTED NEC, STATE AND LOCAL CODES.
3 PROVIDE CONNECTION TO ELEVATOR CONTROLLER FOR NEW ELEVATOR CAR LIGHTS.	3. INSTALL EQUIPMENT GROUNDING CONDUCTORS IN ALL CONDUITS.
4 PROVIDE NEW LIGHT FIXTURES IN ELEVATOR SHAFT AS SHOWN. CONNECT TO ELEVATOR PIT RECEPTACLE CIRCUIT. PROVIDE NEW 3-WAY AND 4-WAY SWITCHES AT EACH ELEVATOR LANDING AND INSTALL NEW ELEVATOR SHAFT WORK LIGHTS AS SHOWN. LOCATE SWITCHES AND LIGHT FIXTURES AS DIRECTED BY ELEVATOR MANUFACTURER.	4. CONTRACTORS ARE TO EXAMINE THE SITE AND DOCUMENTS OF OTHER TRADES, AND BECOME FAMILIAR WITH THE FULL SCOPE OF WORK.
5 PROVIDE ASTRONOMICAL, 1-CKT, 120-277V, TIME CLOCK FOR EXTERIOR SIGN LIGHTING. TIME CLOCK SHALL BE INTERMATIC #E190115C OR ACCEPTABLE EQUAL. PROVIDE WITH MOMENTARY OVERRIDE SWITCH MS-101-WH. PROVIDE ETHERNET CONNECTION.	5. ALL PENETRATIONS FOR RACEWAY AND WIRE WHICH ARE FURNISHED AND INSTALLED BY THE EC, THAT PENETRATE FLOORS, FIRE AND/OR SMOKE WALLS, AND FULL HEIGHT PARTITIONS (INCLUDING CHASE WALLS) SHALL BE SEALED WITH A SYSTEM SPECIFICALLY UL APPROVED FOR THE APPLICATION, TO MAINTAIN FIRE RATING.
	6. CONNECT NEW EXIT/EGRESS LIGHT FIXTURES TO UNSWITCHED LIGHTING CIRCUIT IN SAME ROOM.
	7. PROVIDE DIMMING SWITCH (S _D) WHERE SHOWN. SWITCH SHALL BE 120V, 0-10V, COMPATIBLE WITH LED FIXTURES. WATTS TOPPER RH4FL-3P OR ACCEPTABLE EQUAL.
	8. PROVIDE WALL OCCUPANCY SENSOR SWITCH (S _{OP}) WHERE SHOWN. SWITCH SHALL BE LINE VOLTAGE, AUTO-ON/AUTO-OFF, DUAL TECHNOLOGY, OCCUPANCY SENSOR. WATTS TOPPER DSW-301 OR ACCEPTABLE EQUAL.

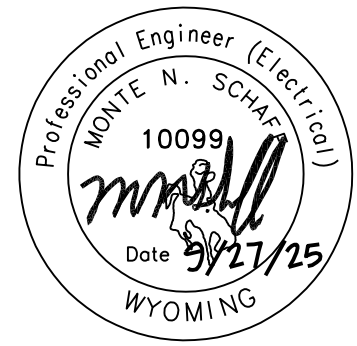

TRONA VALLEY FEDERAL CREDIT UNION
1700 GATEWAY BLVD
ROCK SPRINGS, WYOMING 82901

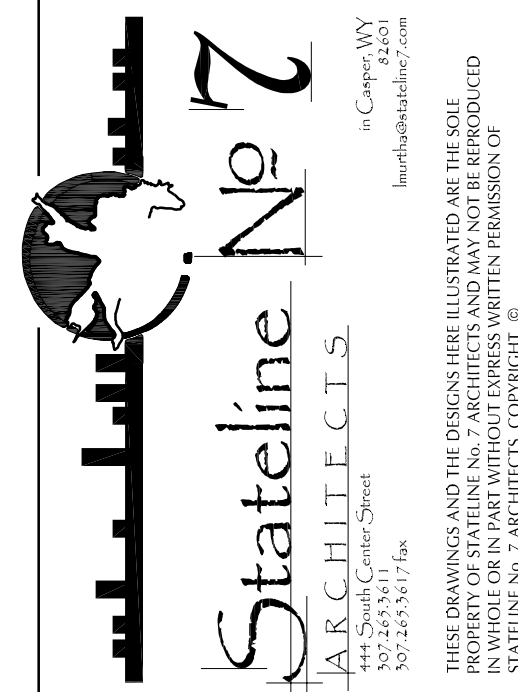

PROJECT NUMBER
23-018 / 24112

DATE
09-27-2025

DRAWN BY
KN

DISK ID.
N/A

SHEET TITLE
SECOND LEVEL
LIGHTING PLAN

SHEET NUMBER

16.23

