


LIGHTING LEGEND		
SYMBOL	TYPE	QUANTITY
	STREETLIGHT SINGLE	14
	STREETLIGHT DOUBLE	1
	LIGHTED BOLLARD	8
	LIGHTED BOLLARD WITH GFCI OUTLET	1
	PEDESTRIAN LIGHT	6
	PEDESTRIAN / STREETLIGHT COMBO	4
	GFCI OUTLET	7
	RAILINGS LIGHTS	±166 LF


FOOTING LEGEND	
SYMBOL	TYPE
	STANDARD CONCRETE FOOTING, PER ELECTRIC PLANS
	FOR LIGHT POLES IN SIDEWALKS, HOLD TOP OF FOOTING 6" ABOVE F.G. SEE DETAIL 3/L112



LIGHTING PLAN

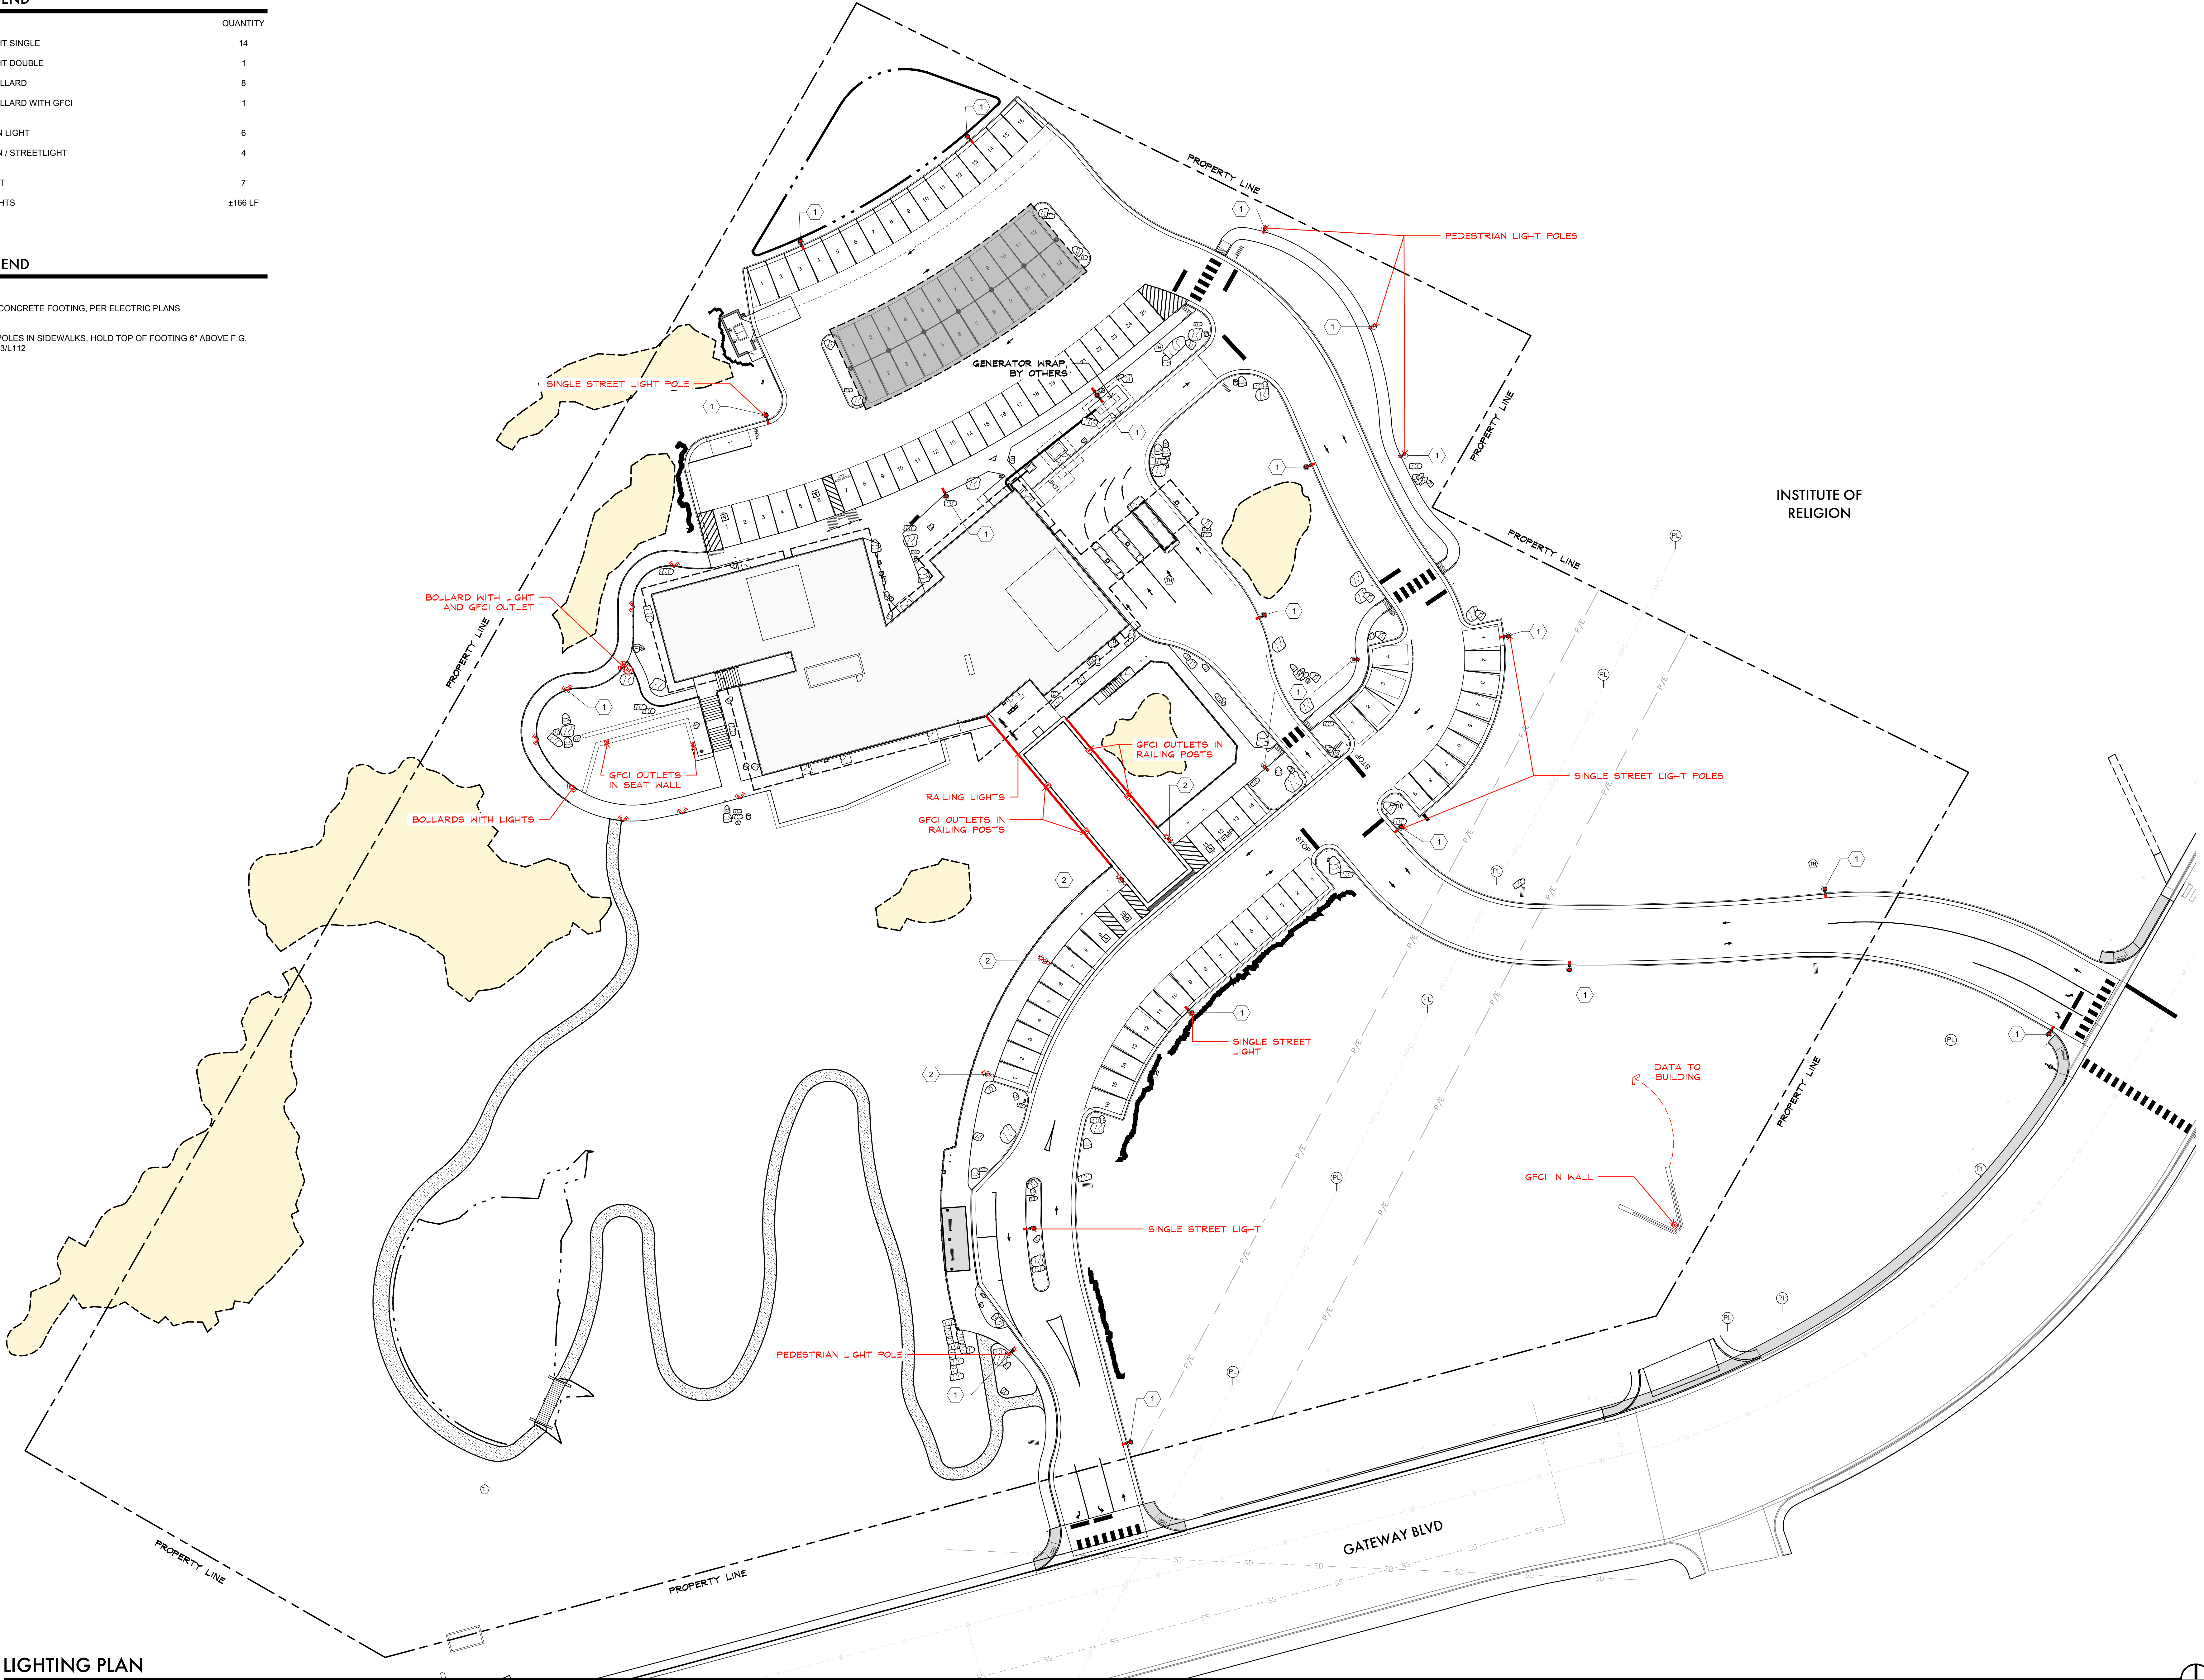

TRONA VALLEY FEDERAL CREDIT UNION
1700 GATEWAY BLVD
ROCK SPRINGS, WYOMING 82901

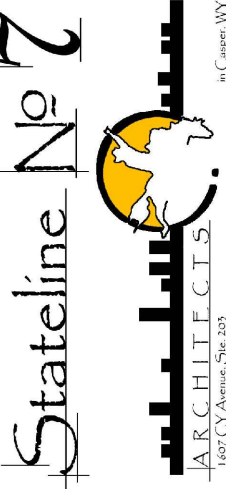

PROJECT NUMBER
23-018

DATE
09-27-2025

DRAWN BY
MATT FRIDELL

DISK ID.

SHEET TITLE
LIGHTING
PLAN

SHEET NUMBER

L103

