


OLD STONEY REMODEL  
PHASE TWO  
120 NORTH 4TH STREET  
SUNDANCE, WYOMING 82729

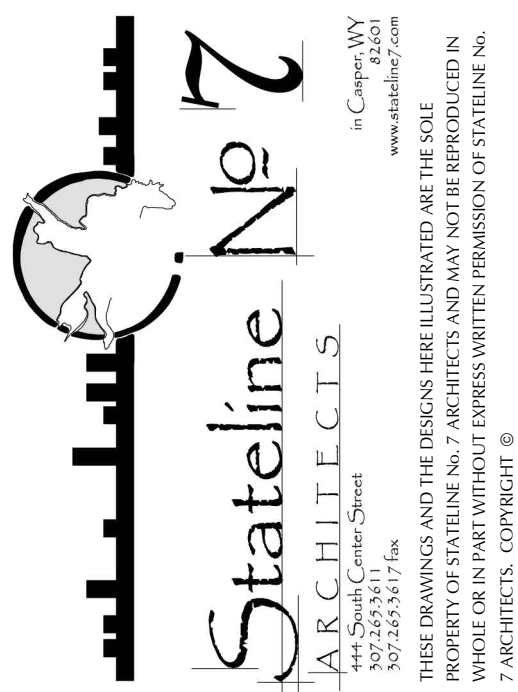

PROJECT NUMBER  
16-022

DATE  
06-30-25

DRAWN BY  
CB

DISK ID.

SHEET TITLE  
SECOND FLOOR  
REFLECTED  
CEILING  
DEMOLITION  
PLAN

SHEET NUMBER

3.05

### GENERAL NOTES

- GENERAL NOTES AND LEGEND ON THIS SHEET REFER TO SHEETS 3.00 AND 3.05 ONLY
- ALL REMOVED/DEMOLISHED ITEMS TO BE PROPERLY DISPOSED OF OFF SITE
- SEE THE STRUCTURAL, MECHANICAL, AND ELECTRICAL DRAWINGS FOR ADDITIONAL DEMOLITION ITEMS
- SEE DIMENSION/REFERENCE PLANS FOR WALL CONSTRUCTION AND OTHER MECHANICAL/ELECTRICAL COORDINATION ITEMS

### KEYNOTES

- 100 EXISTING ATTIC ACCESS LADDER TO BE REMOVED
- 101 EXISTING TIN SOFFIT PANEL TO BE REMOVED AND SALVAGED FOR REUSE
- 102 APPROXIMATE AREA OF CEILING TO BE DEMO'D FOR NEW ATTIC ACCESS HATCH AND ASSOCIATED FRAMING
- 103 FINISH DEMO OF REMAINING PLASTER ON WOOD STUDS, SALVAGE TIN CEILING BORDER AND CORNER PIECES FOR REUSE
- 104 DEMO OF EXISTING WALL BELOW, SEE THE FLOOR DEMOLITION PLAN ON SHEET 3.00
- 105 REMOVE TIN CEILING CORNER PIECE AND SALVAGE FOR REINSTALLATION, SEE SHEET 3.00

### REFLECTED CEILING LEGEND

- EXISTING ITEMS TO REMAIN, SEE OTHER SHEETS FOR SALVAGED/RELOCATED ITEMS
- GYPSUM BOARD CEILING/SOFFIT/HEADER
- UNREMOVABLE TIN CEILING TILE TO BE DEMO'D
- 2' X 2' TIN CEILING TILE TO BE REMOVED AND SALVAGED FOR REUSE
- 4'-0" X 1'-6" TIN CEILING BRAD PANEL TO BE REMOVED AND SALVAGED FOR REUSE
- UNREMOVABLE 4'-0" X 1'-6" TIN CEILING BRAD PANEL TO BE DEMO'D
- XX'-XX" HEIGHT OF CEILING/SOFFIT FROM FLOOR IMMEDIATELY BELOW
- APPROXIMATE LOCATION OF EXISTING FIRE SPRINKLER HEAD, SEE FIRE PROTECTION PLAN FOR RELOCATIONS, PROVIDE PATCHES IN DRYWALL FOR RELOCATED SPRINKLER HEADS

## SECOND FLOOR REFLECTED CEILING DEMOLITION PLAN

SCALE: 1/4" = 1'-0"

