



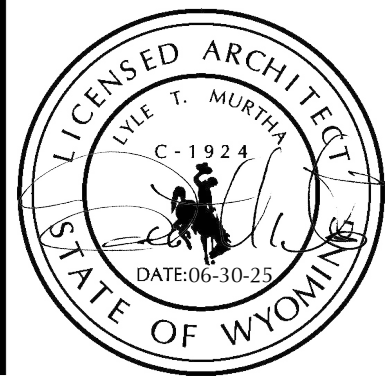

OLD STONEY REMODEL
PHASE TWO
120 NORTH 4TH STREET
SUNDANCE, WYOMING 82729

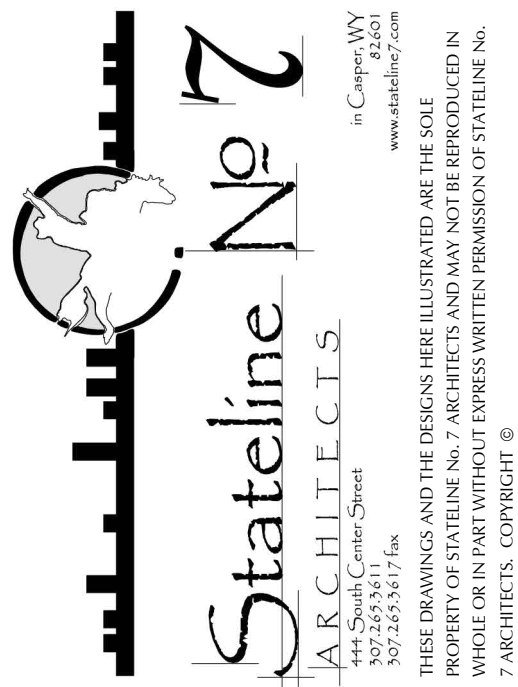

GENERAL NOTES


1. GENERAL NOTES, KEYNOTES, AND LEGEND ON THIS SHEET REFER TO THIS SHEET ONLY.
2. SEE THE STRUCTURAL, MECHANICAL, AND ELECTRICAL DRAWINGS FOR ADDITIONAL INFORMATION.
3. SEE THE DOOR AND WINDOW SHEETS AND BUILDING ELEVATIONS FOR INFORMATION REGARDING OPENINGS LABELED ON THIS SHEET.
4. ALL 90 DEGREE OUTSIDE DRYMALL CORNERS TO BE SQUARE TYPICAL UNLESS NOTED OTHERWISE.
5. SEE FINISH PLANS FOR INFORMATION REGARDING INTERIOR SIGNAGE.
6. SEE FURNITURE AND EQUIPMENT PLANS FOR ITEMS NOT SHOWN ON THIS PLAN BUT HAVE COORDINATION WITH STRUCTURAL, MECHANICAL OR ELECTRICAL ITEMS.
7. SEE DIMENSION PLANS FOR ALL WALL TYPES AND CONSTRUCTION SHOWN ON THESE SHEETS.

LEGEND

- (1.20) KEYNOTE SYMBOL (SEE KEYNOTES FOR CORRESPONDING INFO)
- F.E.G. FIRE EXTINGUISHER AND CABINET, SEE THE ACCESSORIES LEGEND ON SHEET 8.15
- ⊖ FLOOR DRAIN LOCATION, SEE MECHANICAL DRAWINGS
- ⊙ STAGE FOOTLIGHT, SEE THE ELECTRICAL DRAWINGS



KEYNOTES

- 300 PROJECTOR LOCATION IN SOFFIT ABOVE, SEE 1/3.20
- 301 TV / DISPLAY LOCATION, CONTRACTOR TO COORDINATE BLOCKING AS NEEDED FOR MOUNTING IN THESE LOCATIONS, SEE ELECTRICAL PLANS FOR POWER/DATA OUTLETS
- 302 OPERABLE WALL PARTITION, MANUAL OPERATION, SEE SHEET 10.10 AND SPECIFICATIONS
- 303 MOP SINK LOCATION, SEE MECHANICAL DRAWINGS
- 304 FRONT OF STAGE TO BE RE-FINISHED WITH BEAD BOARD SEE INTERIOR ELEVATIONS
- 305 DASHED LINE INDICATES LOCATION OF ELECTRIC PROJECTION SCREEN ABOVE, SEE ELECTRICAL DRAWINGS
- 306 LINES INDICATE APPROXIMATE LOCATION OF STAGE CURTAINS, SEE FURNITURE PLAN, AND INTERIOR ELEVATIONS FOR MORE INFORMATION
- 307 FIRE SPRINKLER INSPECTION LINE TO BE RELOCATED, SEE MECHANICAL DRAWINGS/FIRE PROTECTION DRAWINGS
- 308 PROVIDE OPENINGS IN STAGE FLOOR FOR FOOT LIGHTS, COORDINATE WITH THE ELECTRICAL DRAWINGS

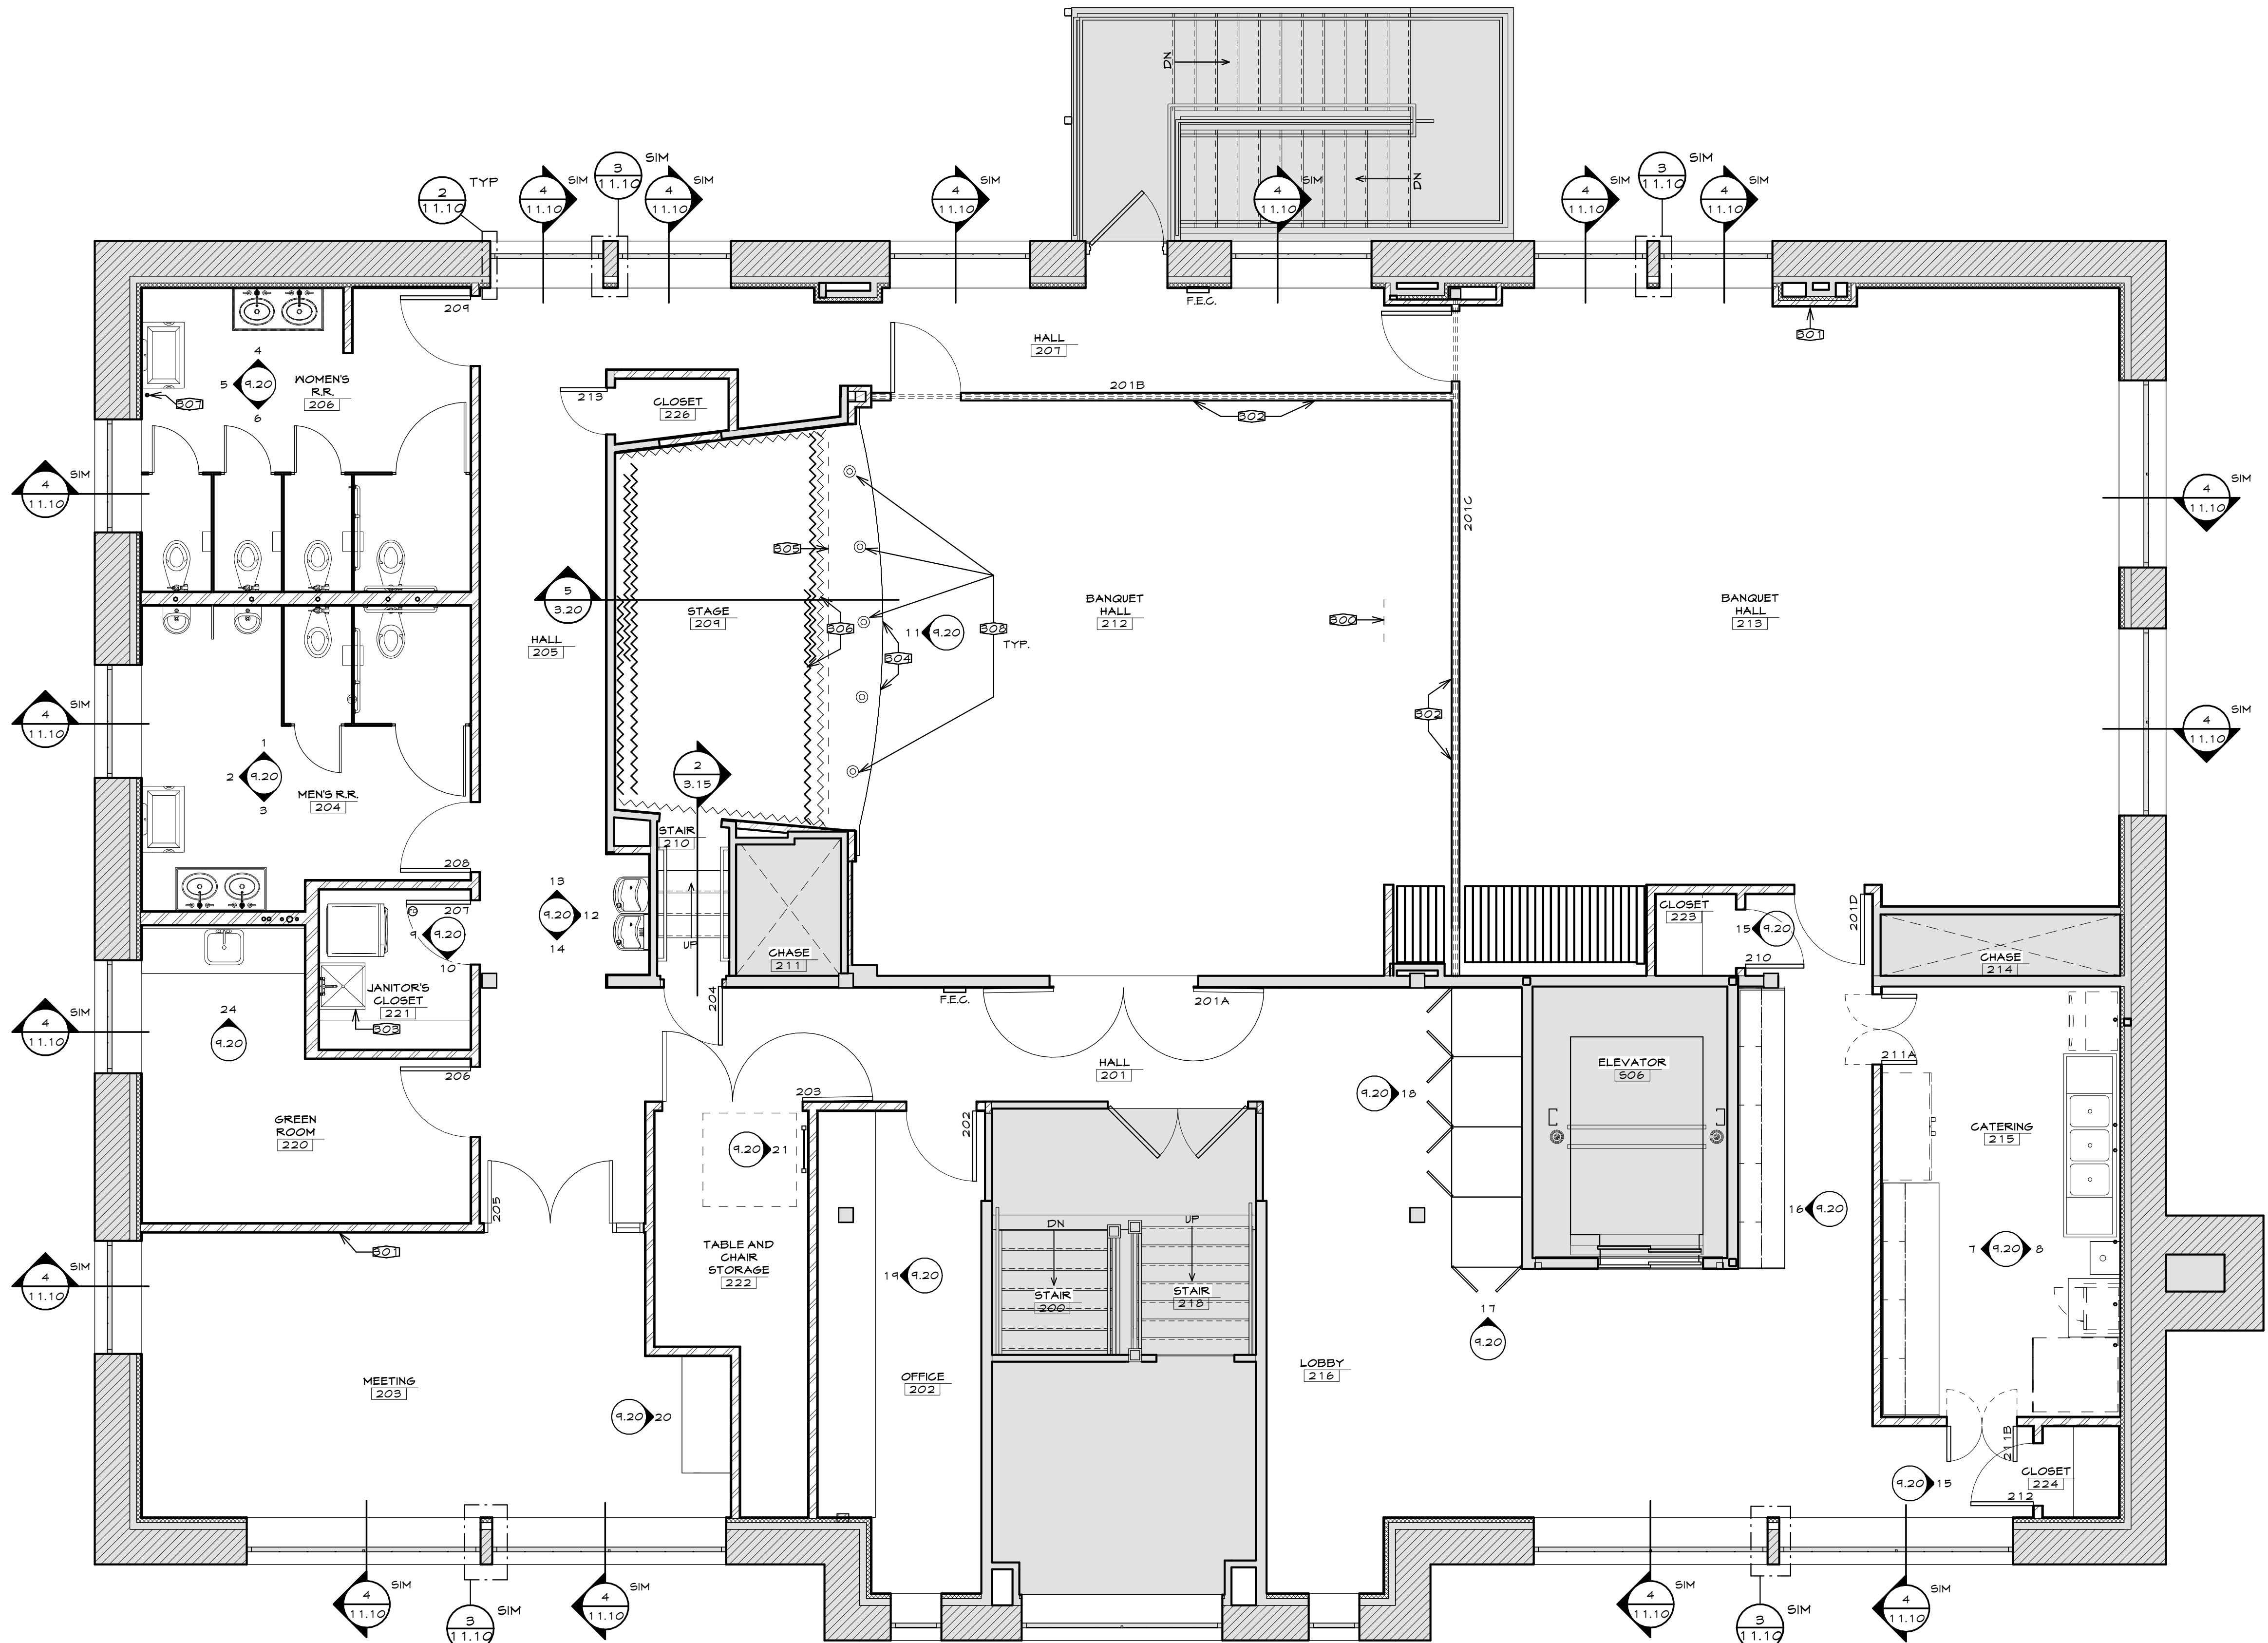


SECOND FLOOR REFERENCE PLAN

SCALE: 1/4" = 1'-0"

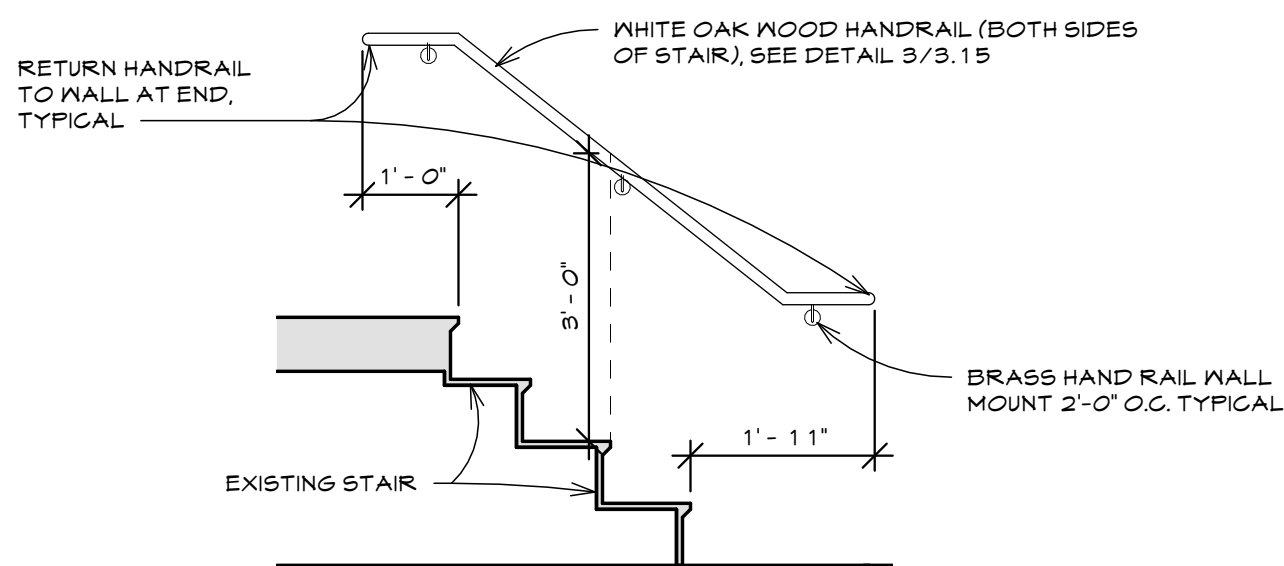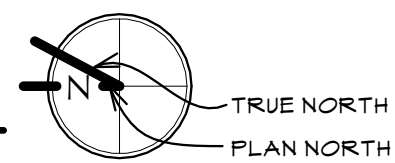


STAGE STAIR SECTION

SCALE: 1/2" = 1'-0"

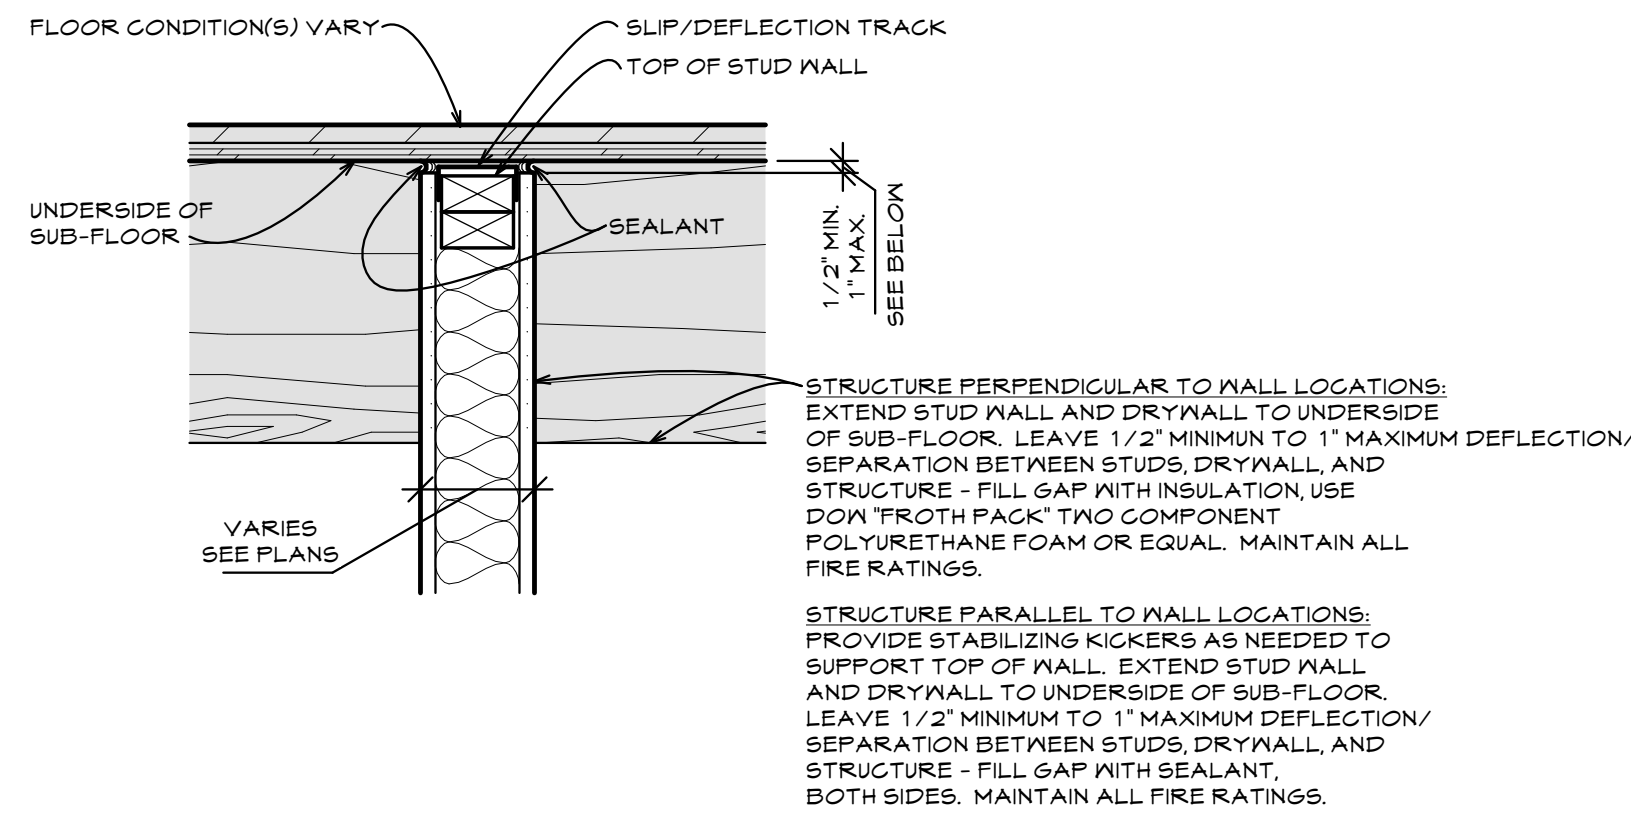

DEFLECTION HEAD

SCALE: 1 1/2" = 1'-0"

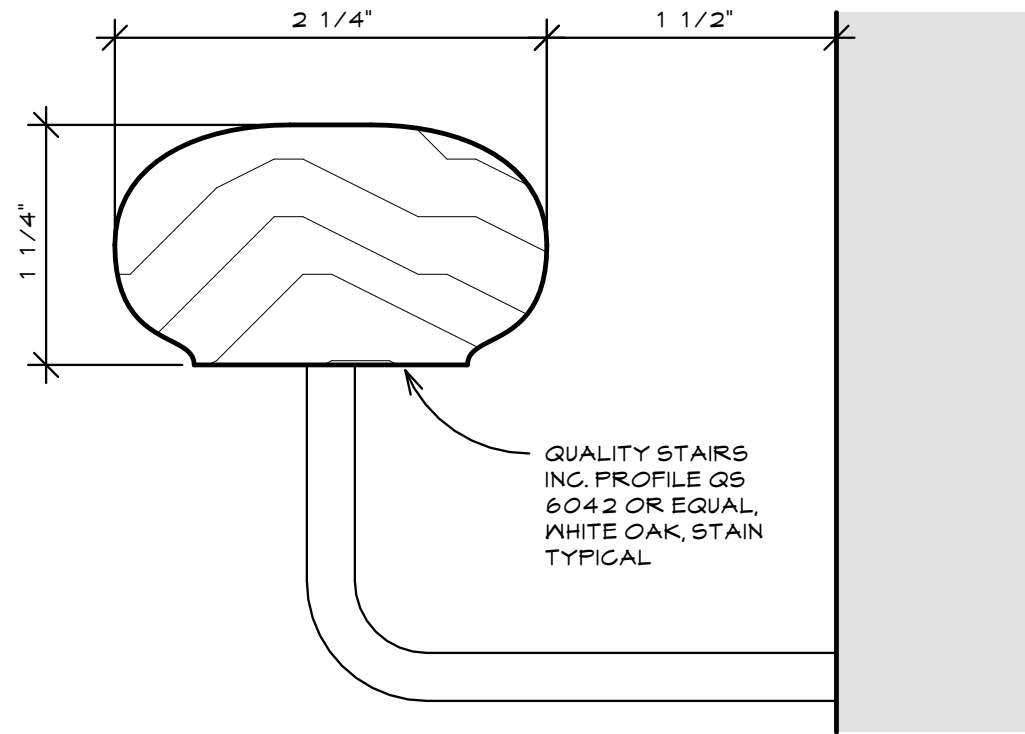

WOOD HANDRAIL PROFILE

SCALE: 1/2" = 1'-0"

PROJECT NUMBER

16-022

DATE

06-30-25

DRAWN BY

CB

DISK ID.

SHEET TITLE

SECOND FLOOR
REFERENCE PLAN

SHEET NUMBER

3.15